

ISSUED FOR

- 1 2020-06-11 ISSUED FOR ZBA
- 2 2021-09-08 REISSUED FOR ZBA
- 3 2021-09-08 ISSUED FOR SPA
- 4 2022-10-12 REISSUED FOR ZBA
- 5 2023-01-23 REISSUED FOR ZBA
- 6 2023-10-26 REISSUED FOR ZBA

METRIC

THIS DRAWING IS COPYRIGHTED AND MUST NOT BE USED, REPRODUCED, OR REUSED WITHOUT WRITTEN PERMISSION. ALL DIMENSIONS ARE IN MILLIMETERS UNLESS OTHERWISE NOTED. VERIFY DIMENSIONS DO NOT SCALE THIS DRAWING. REPORT INCONSISTENCIES AND OMISSIONS TO THE CONSULTANT FOR CLARIFICATION BEFORE COMMENCING WITH THE WORK. DEVIATIONS FROM THE CONTRACT DOCUMENTS WITHOUT WRITTEN APPROVAL FROM THE CONSULTANT ARE SUBJECT TO CORRECTION AT THE CONTRACTOR'S EXPENSE.

ARCHITECT & PRIME CONSULTANT

DIALOG
35 John St #200
Toronto, ON M5V 3G6
Tel: (416) 966-0220 Fax:

CIVIL ENGINEER
Courtesport Engineering Inc.
8395 Jane St, Suite 100
Vaughan, ON L4K 5Y2
Tel: (905) 526-1404 Fax:

LANDSCAPE ARCHITECT
Ferra & Associates Inc
11 Church St
Toronto, ON M5E 1W1
Tel: (416) 366-6800 Fax:

STRUCTURAL ENGINEER
Jadlovsky, Asif and Partners International
400-3 Concorde Gate
Toronto, ON M6C 3N7
Tel: (416) 447-7405 Fax:

MECHANICAL ENGINEER
Smith + Anderson
100 Sheppard Ave E
North York, ON M2N 6N5
Tel: (416) 487-8151 Fax:

ELECTRICAL ENGINEER

Tel: Fax:

KEYPLAN

SEAL

YONGE & GERRARD





FLOOR PLANS


DRAWN: Author CHECKED: Checker
PLOT DATE: 2023-10-24 13:47:10

DP2.1


ABXXXXX - 11161T

Autodesk Docs 011161T - YONGE GERRARD MIX
USE/1161T_YONGEGERRARD.rvt

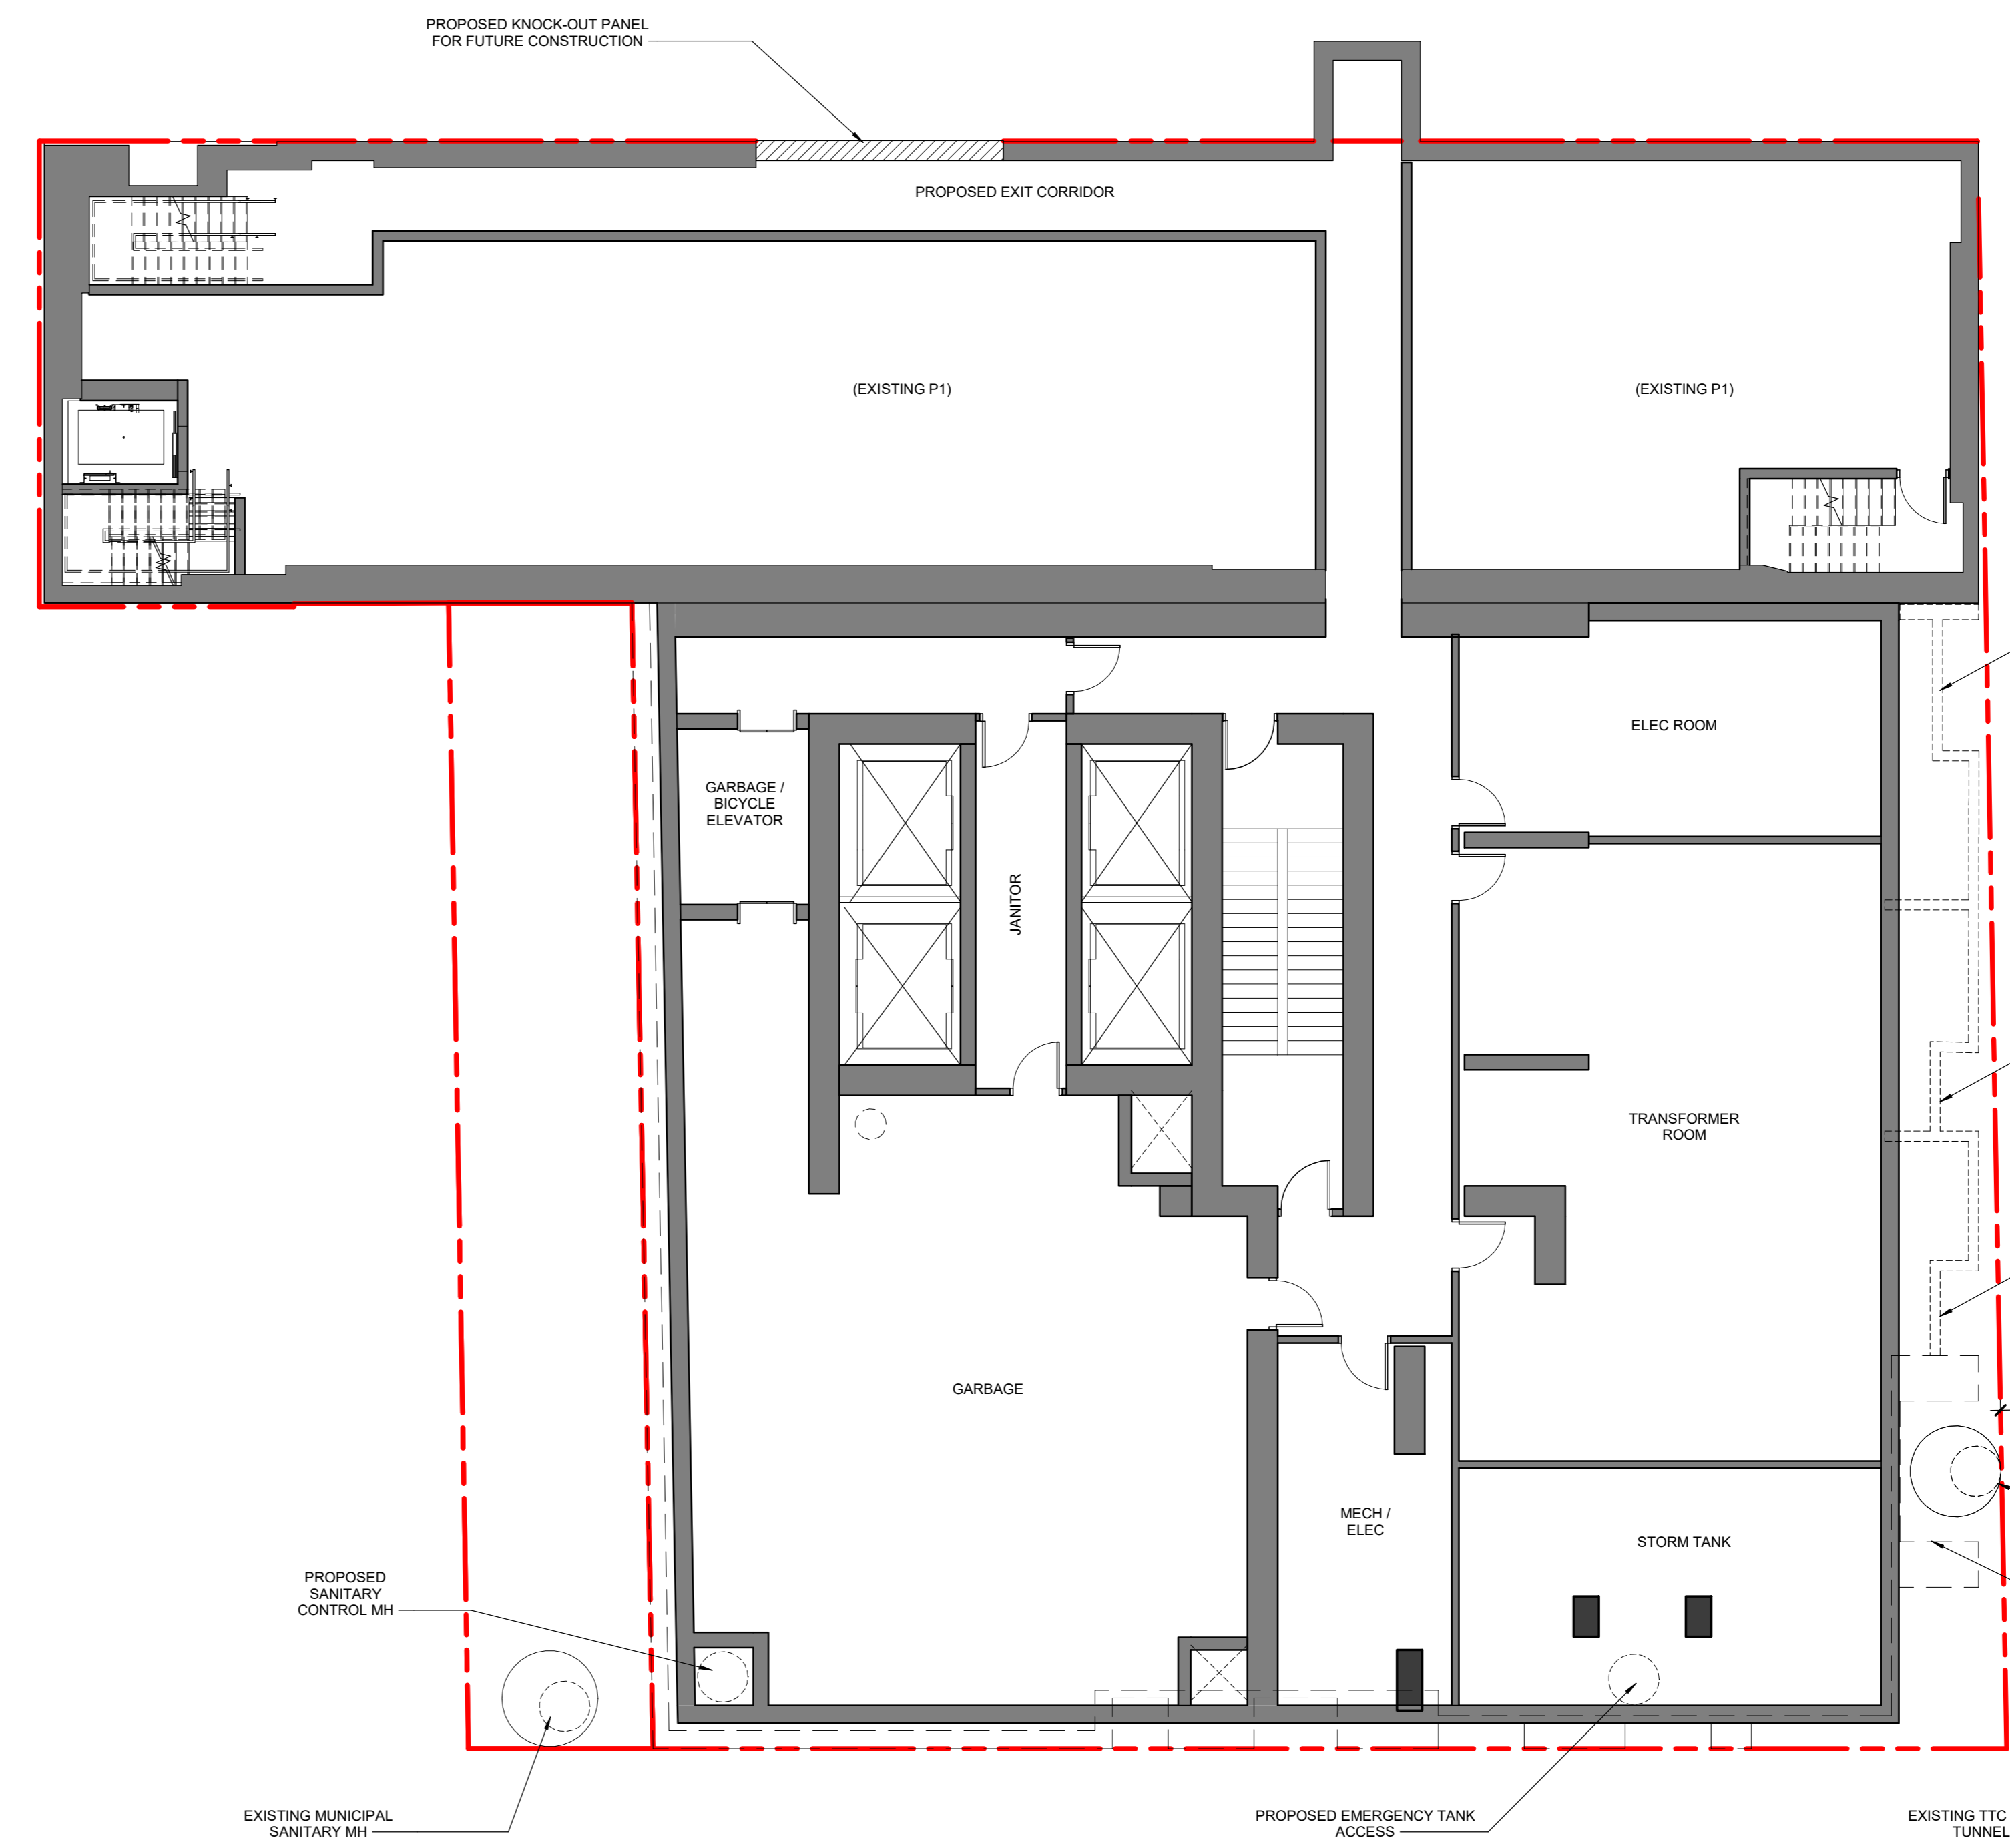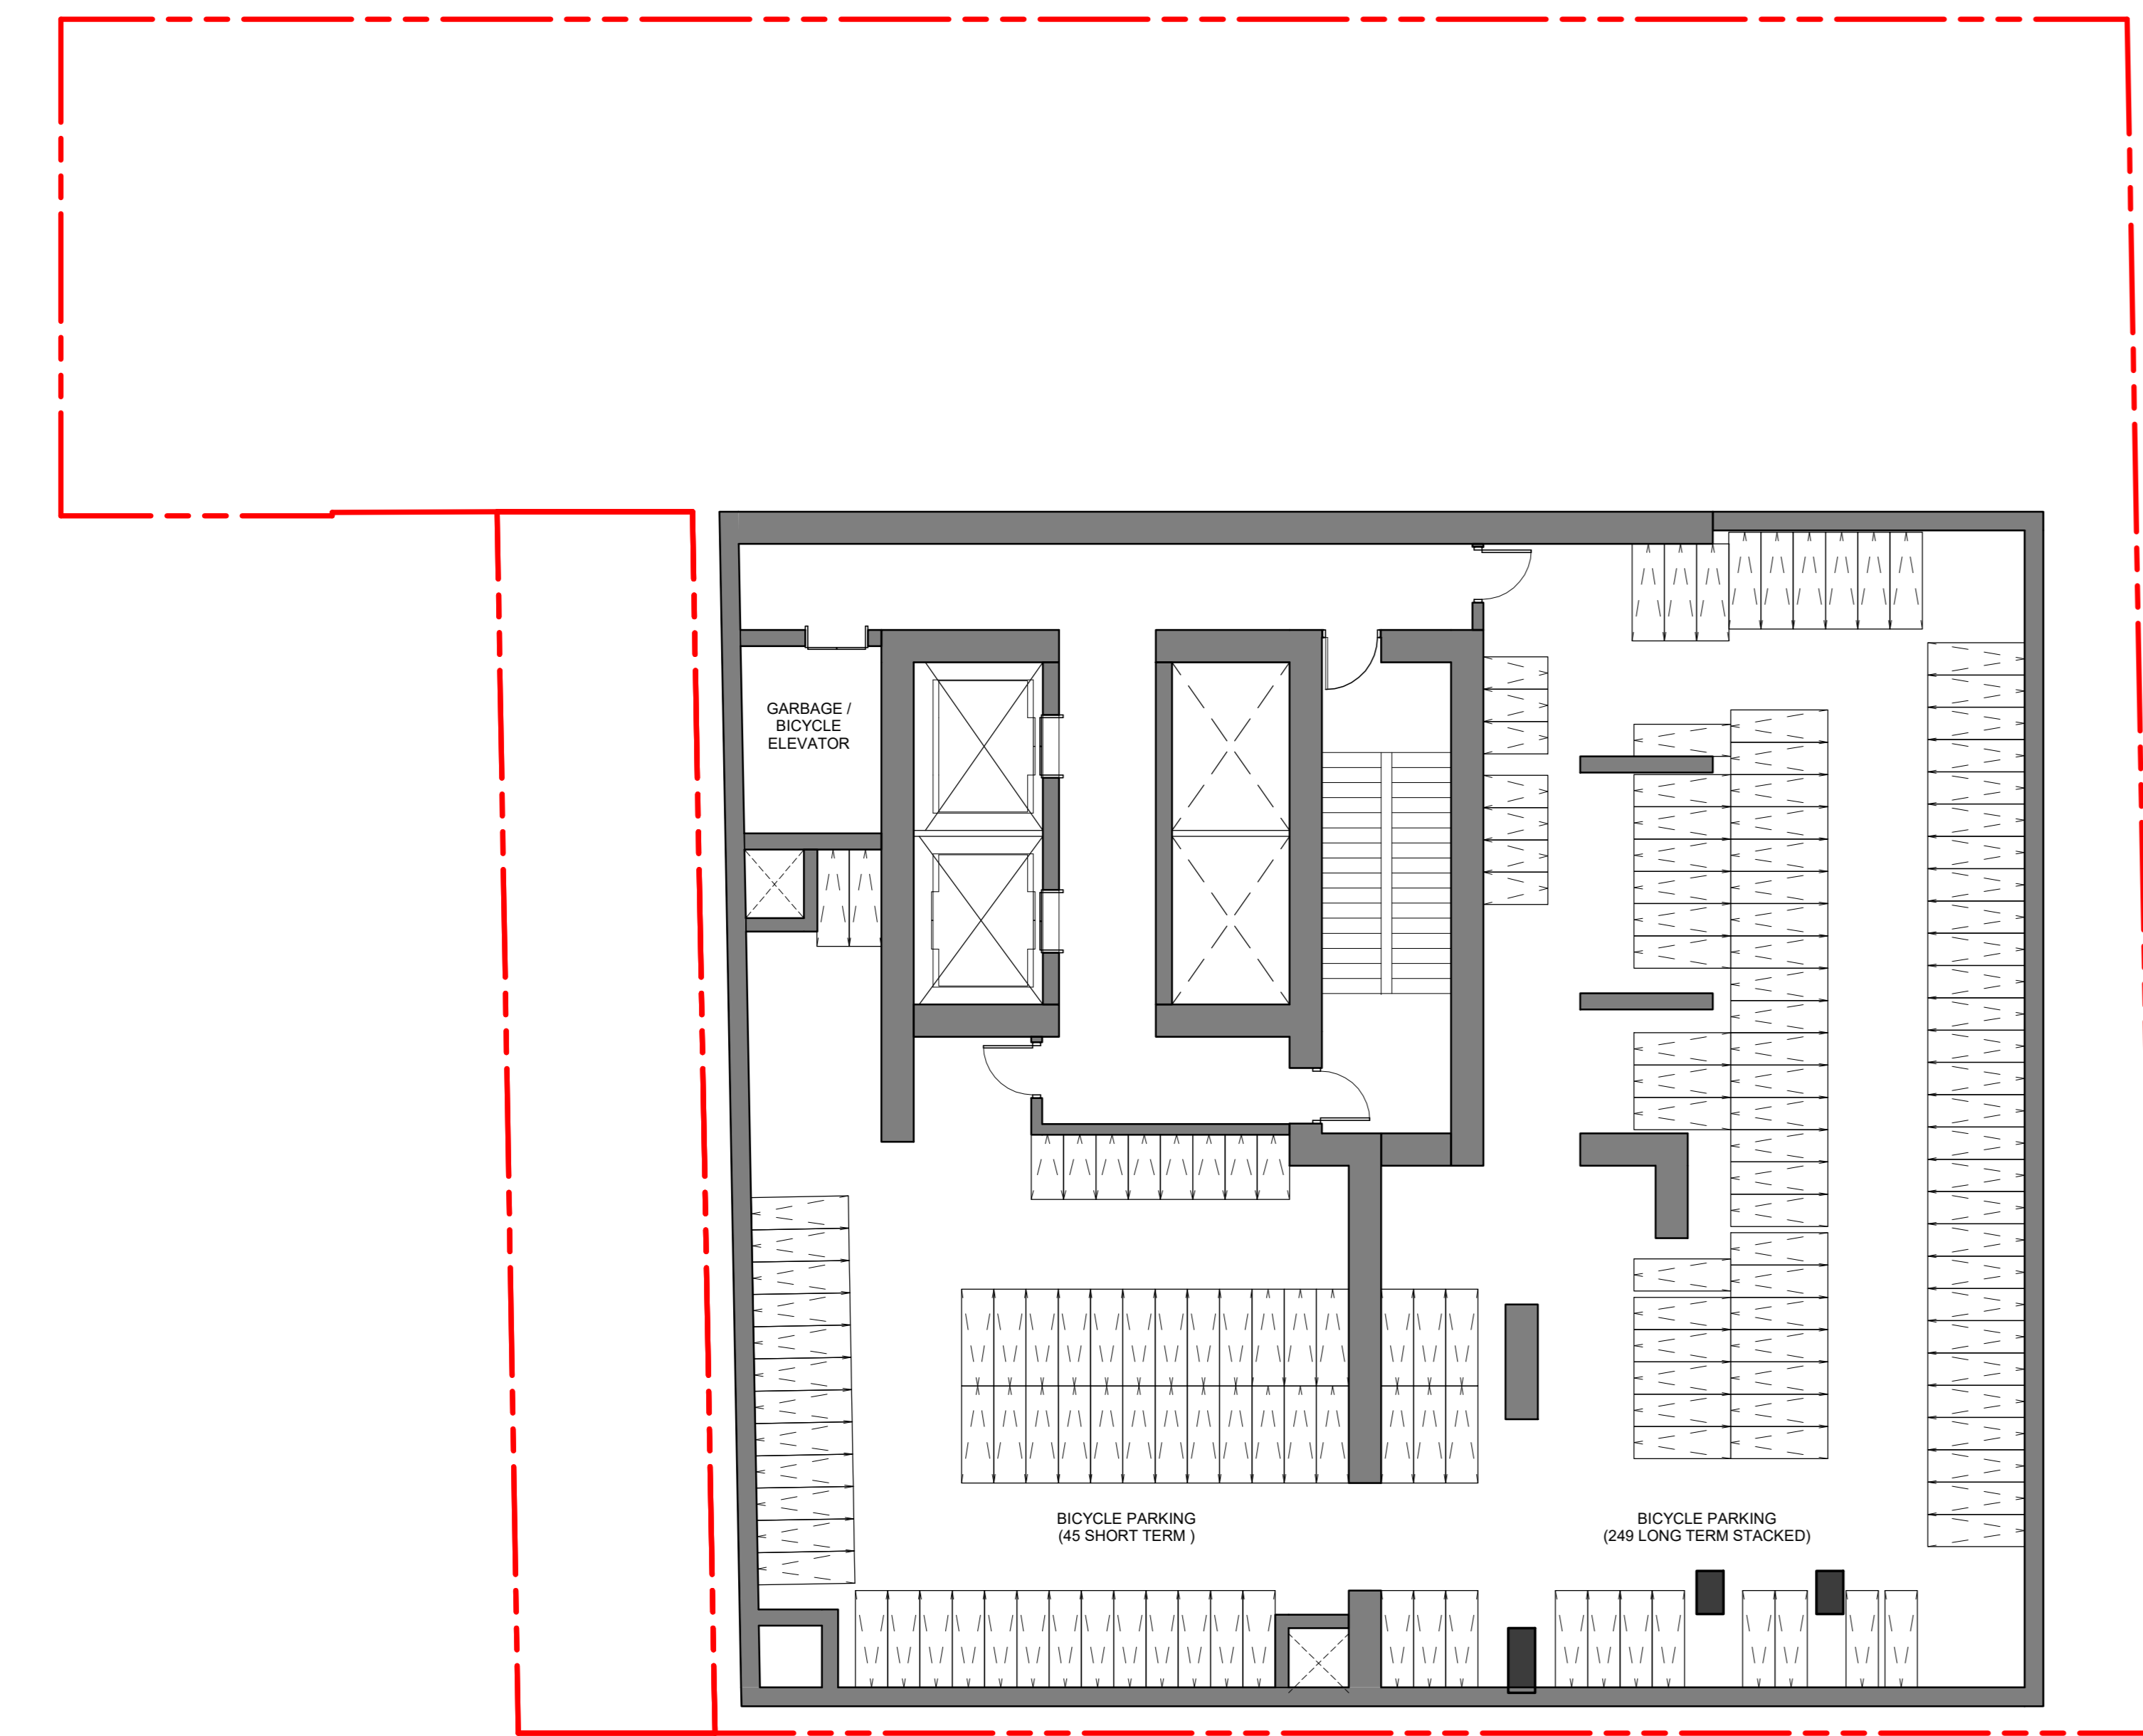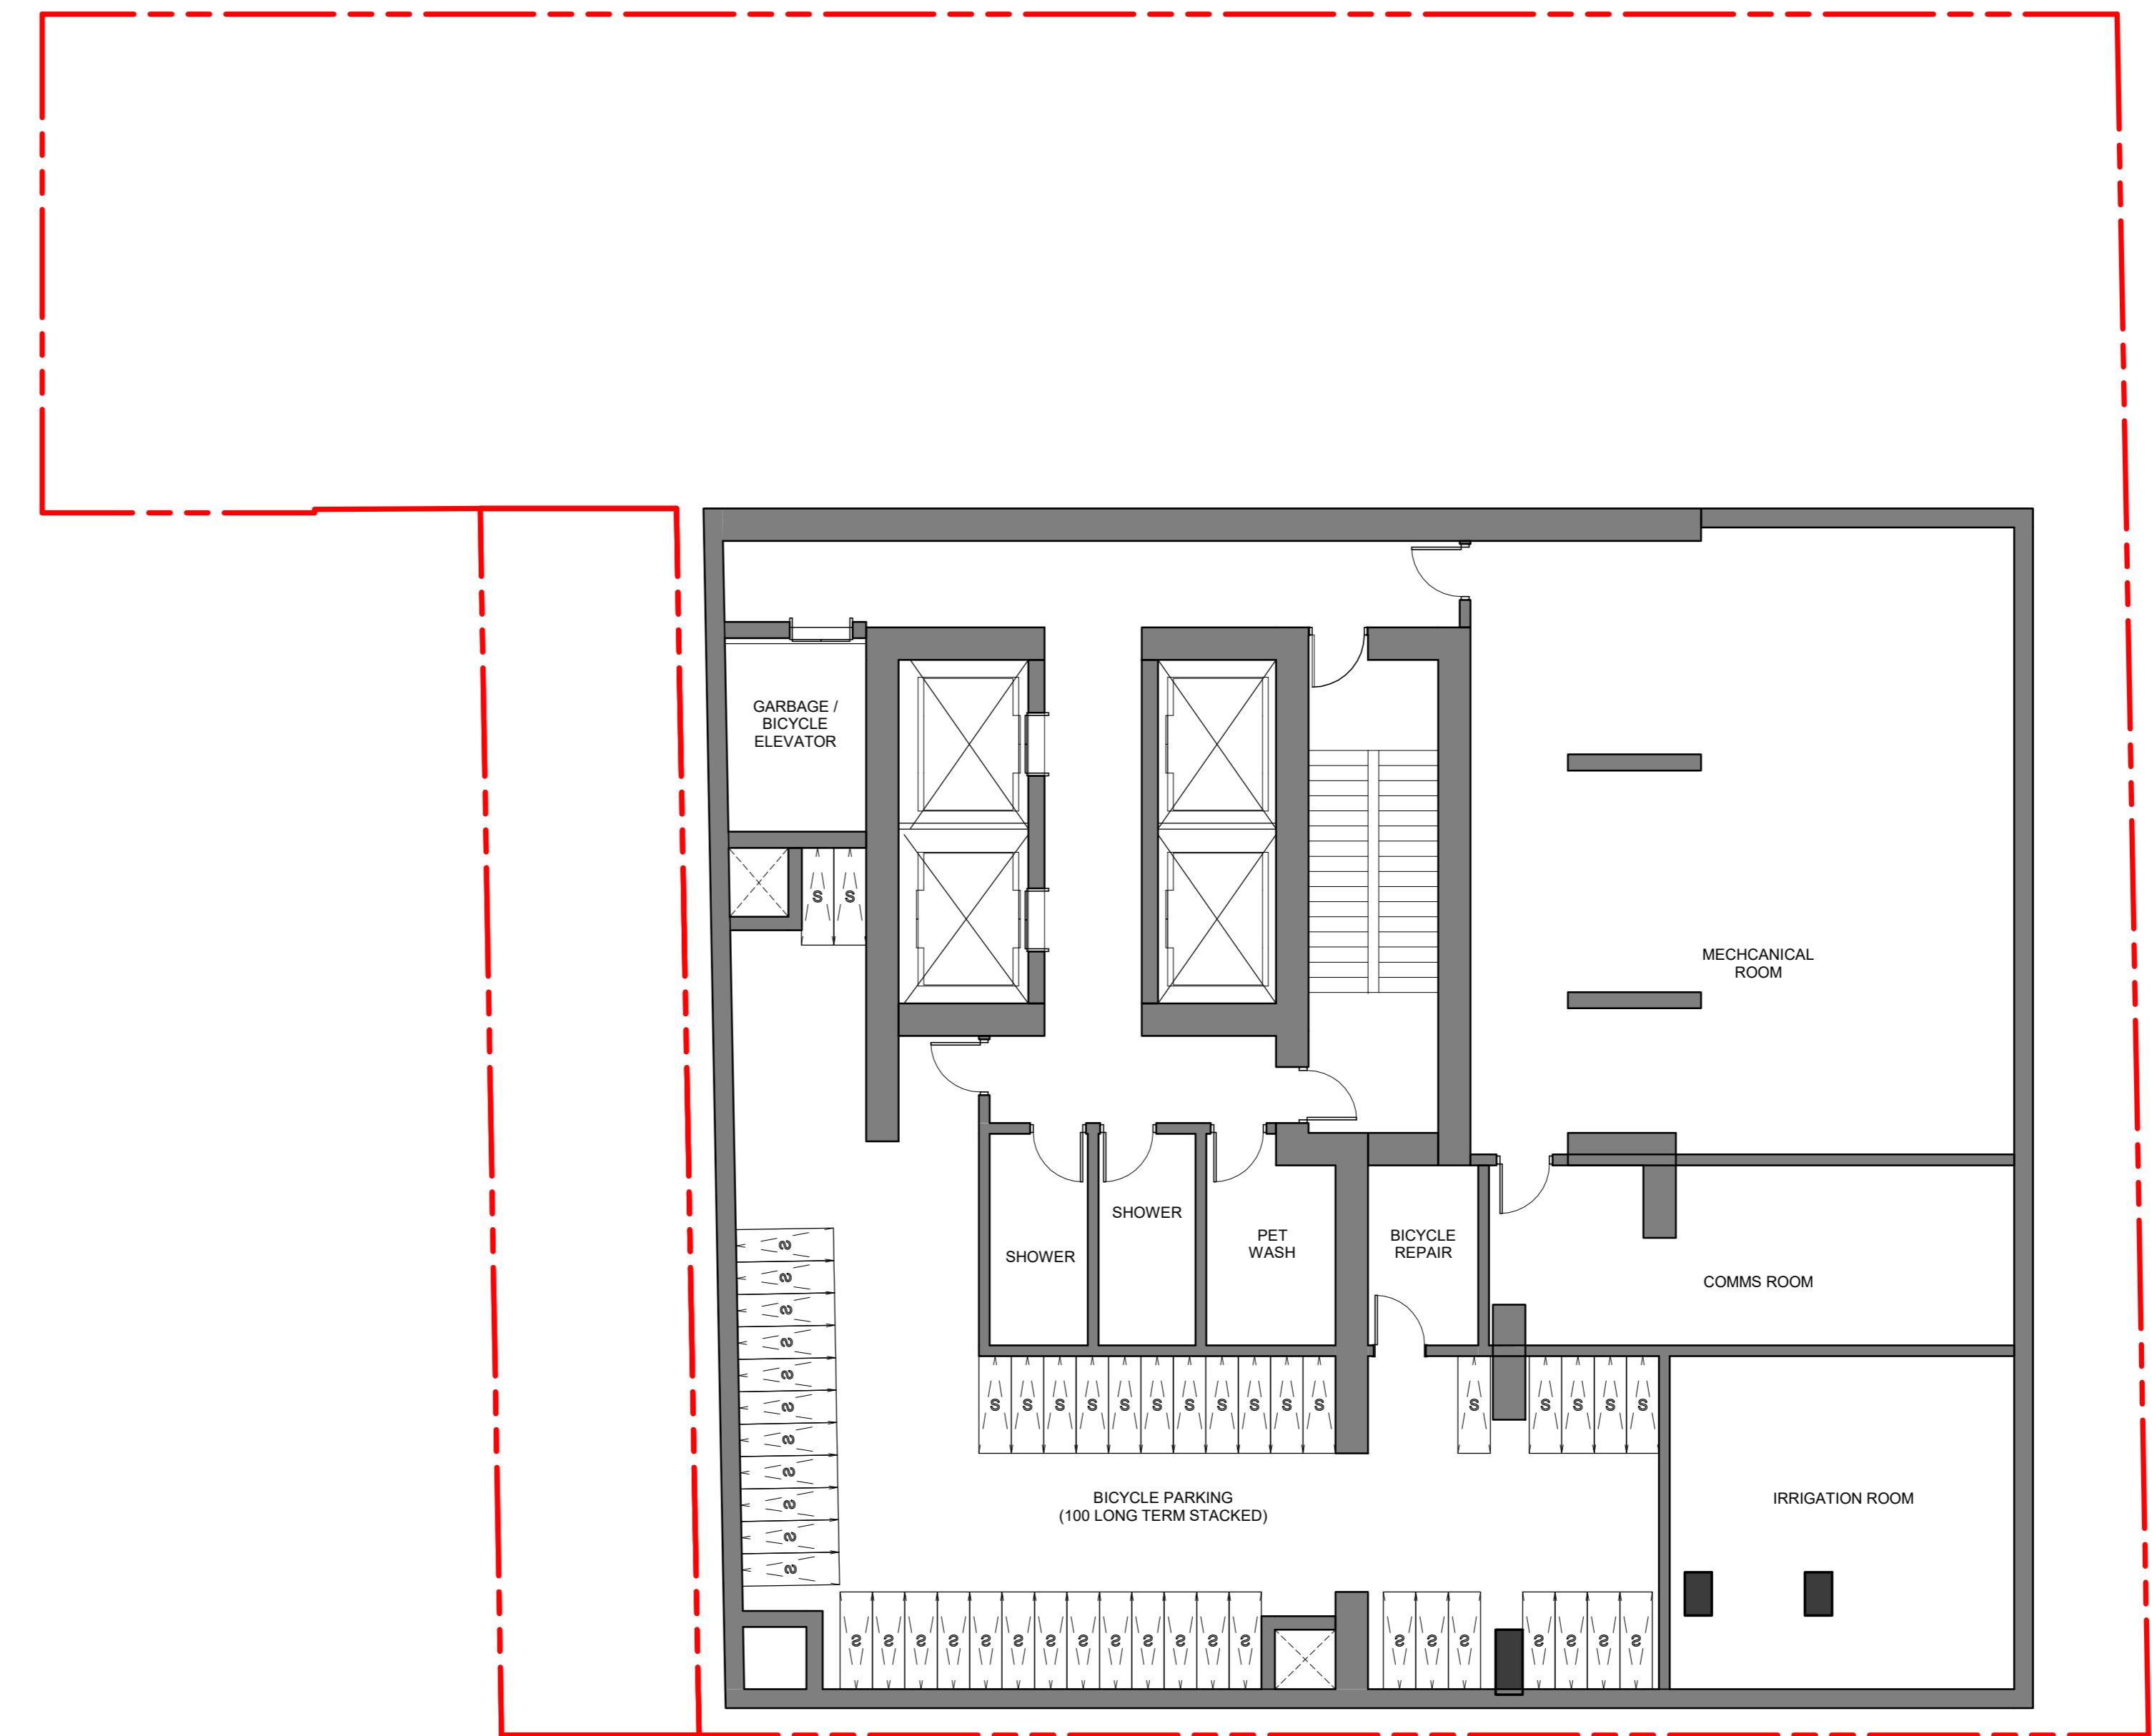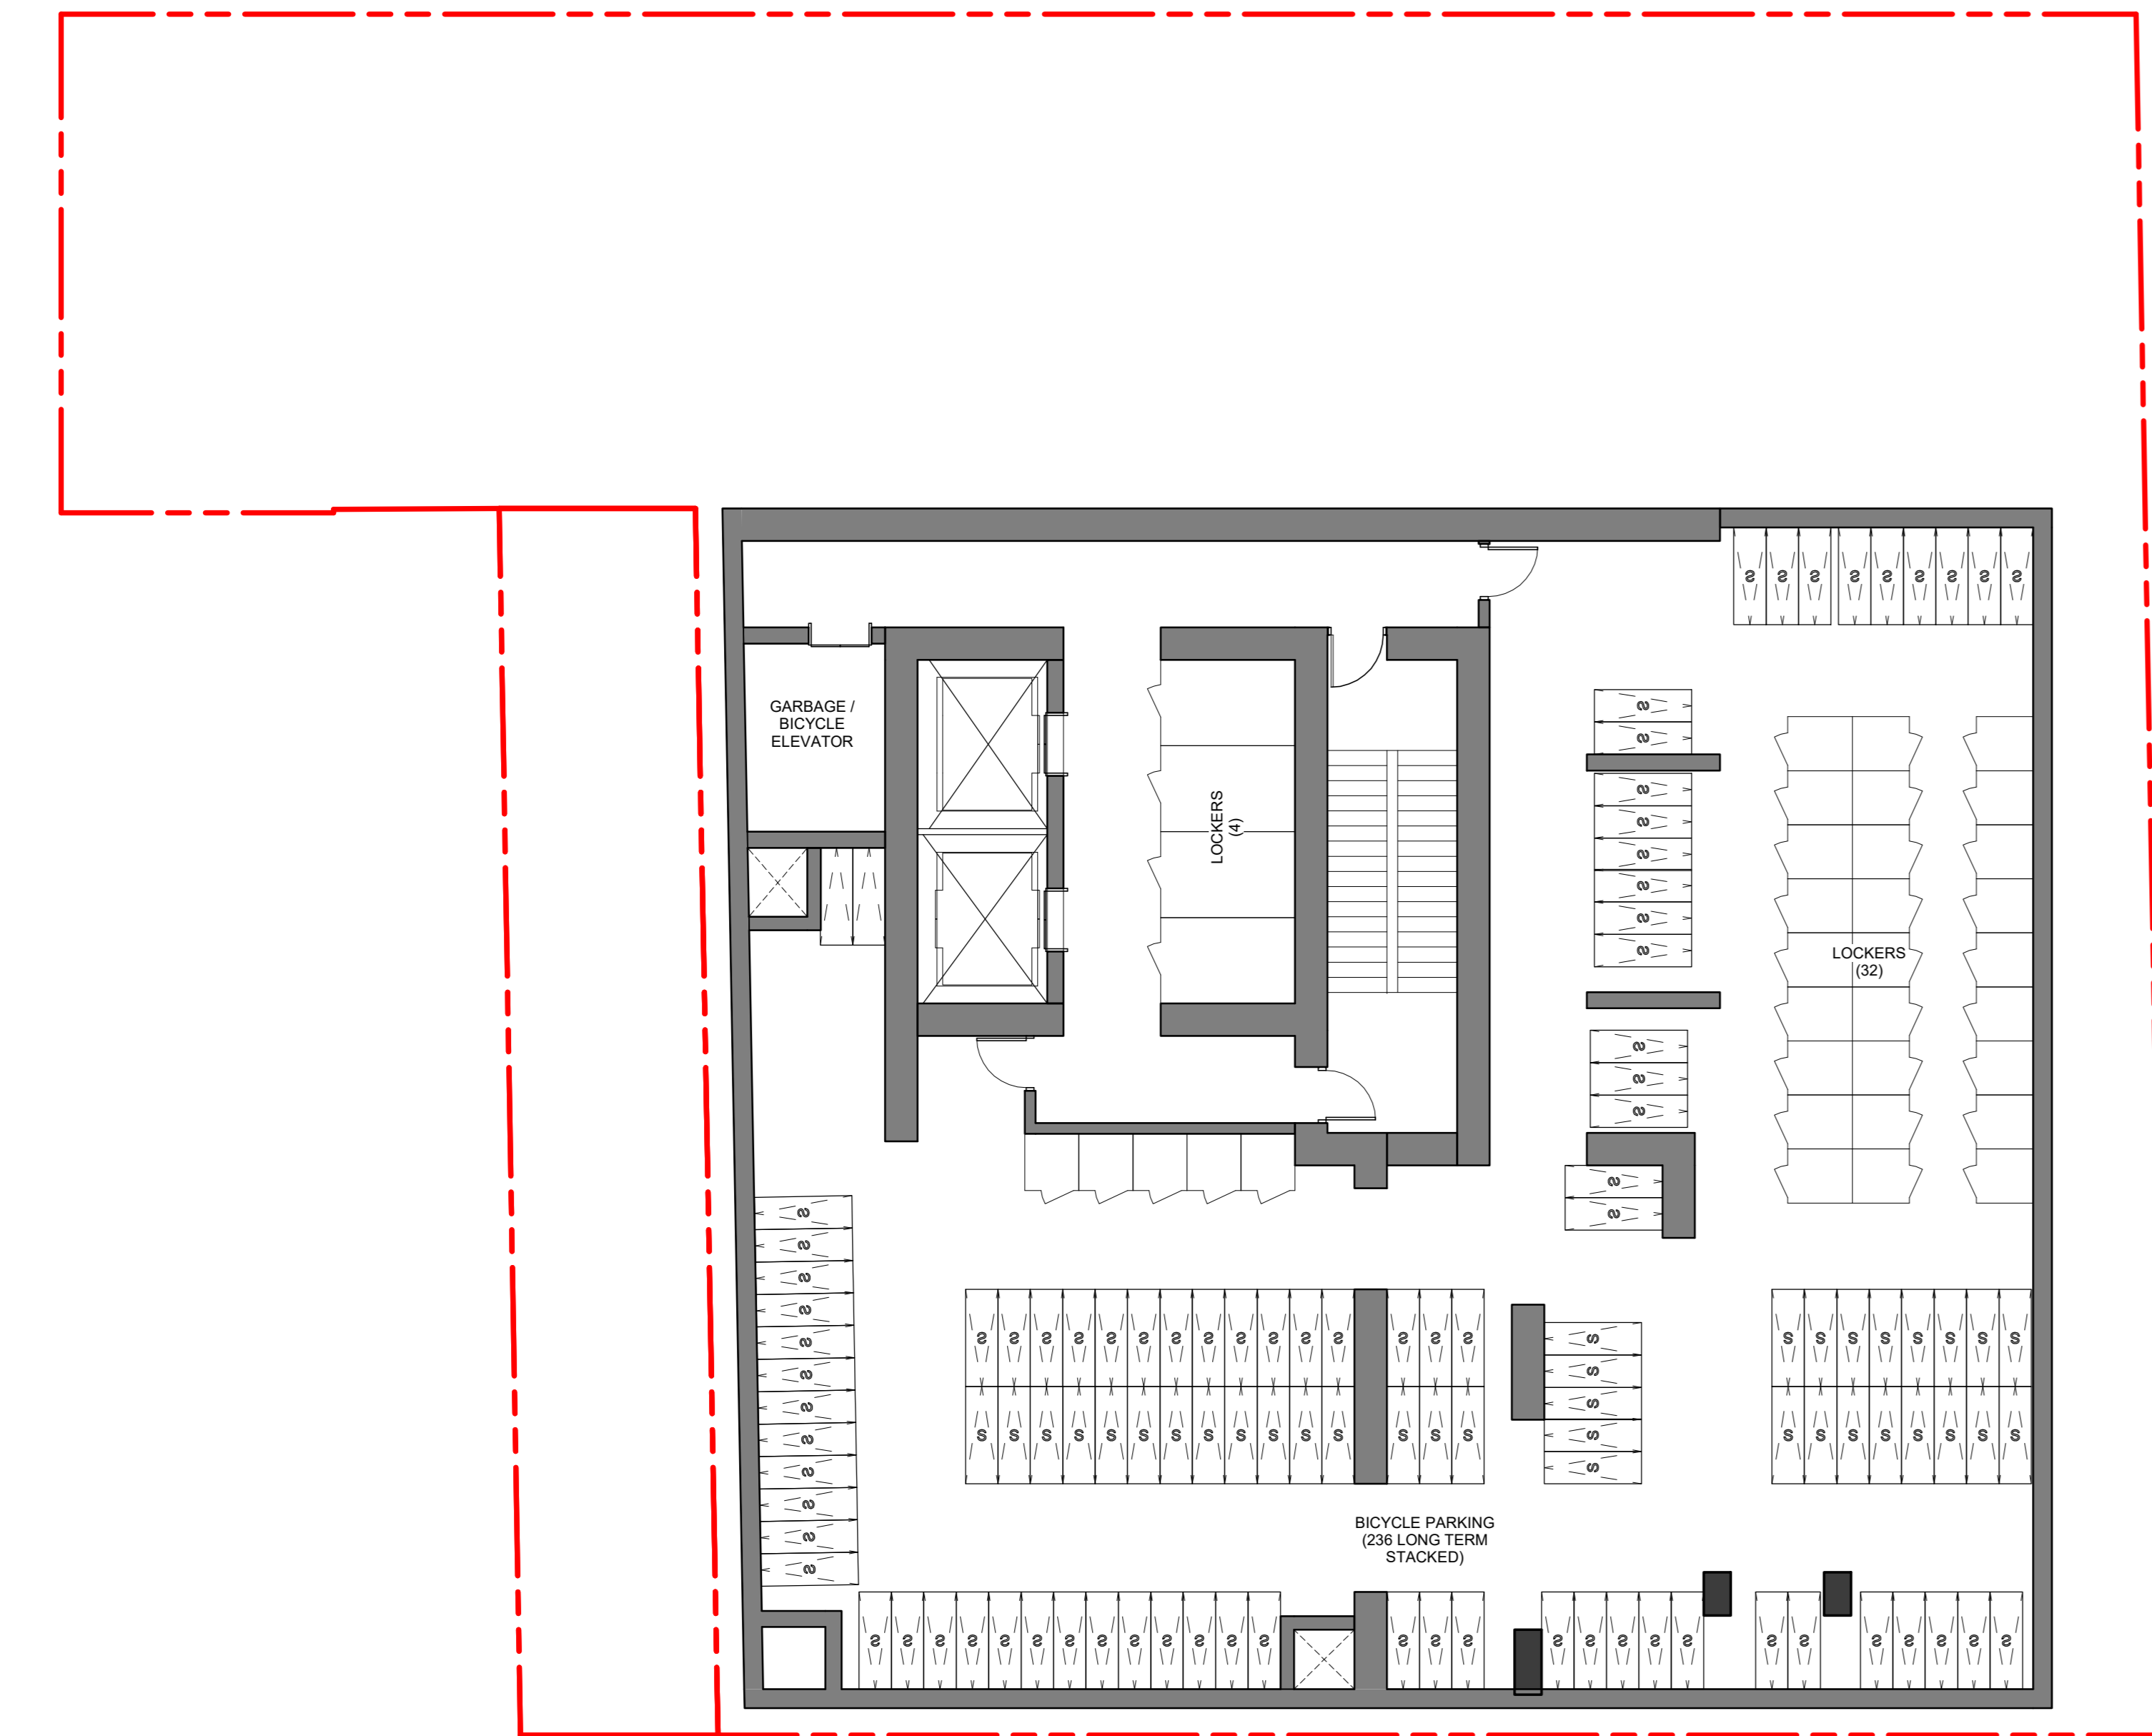


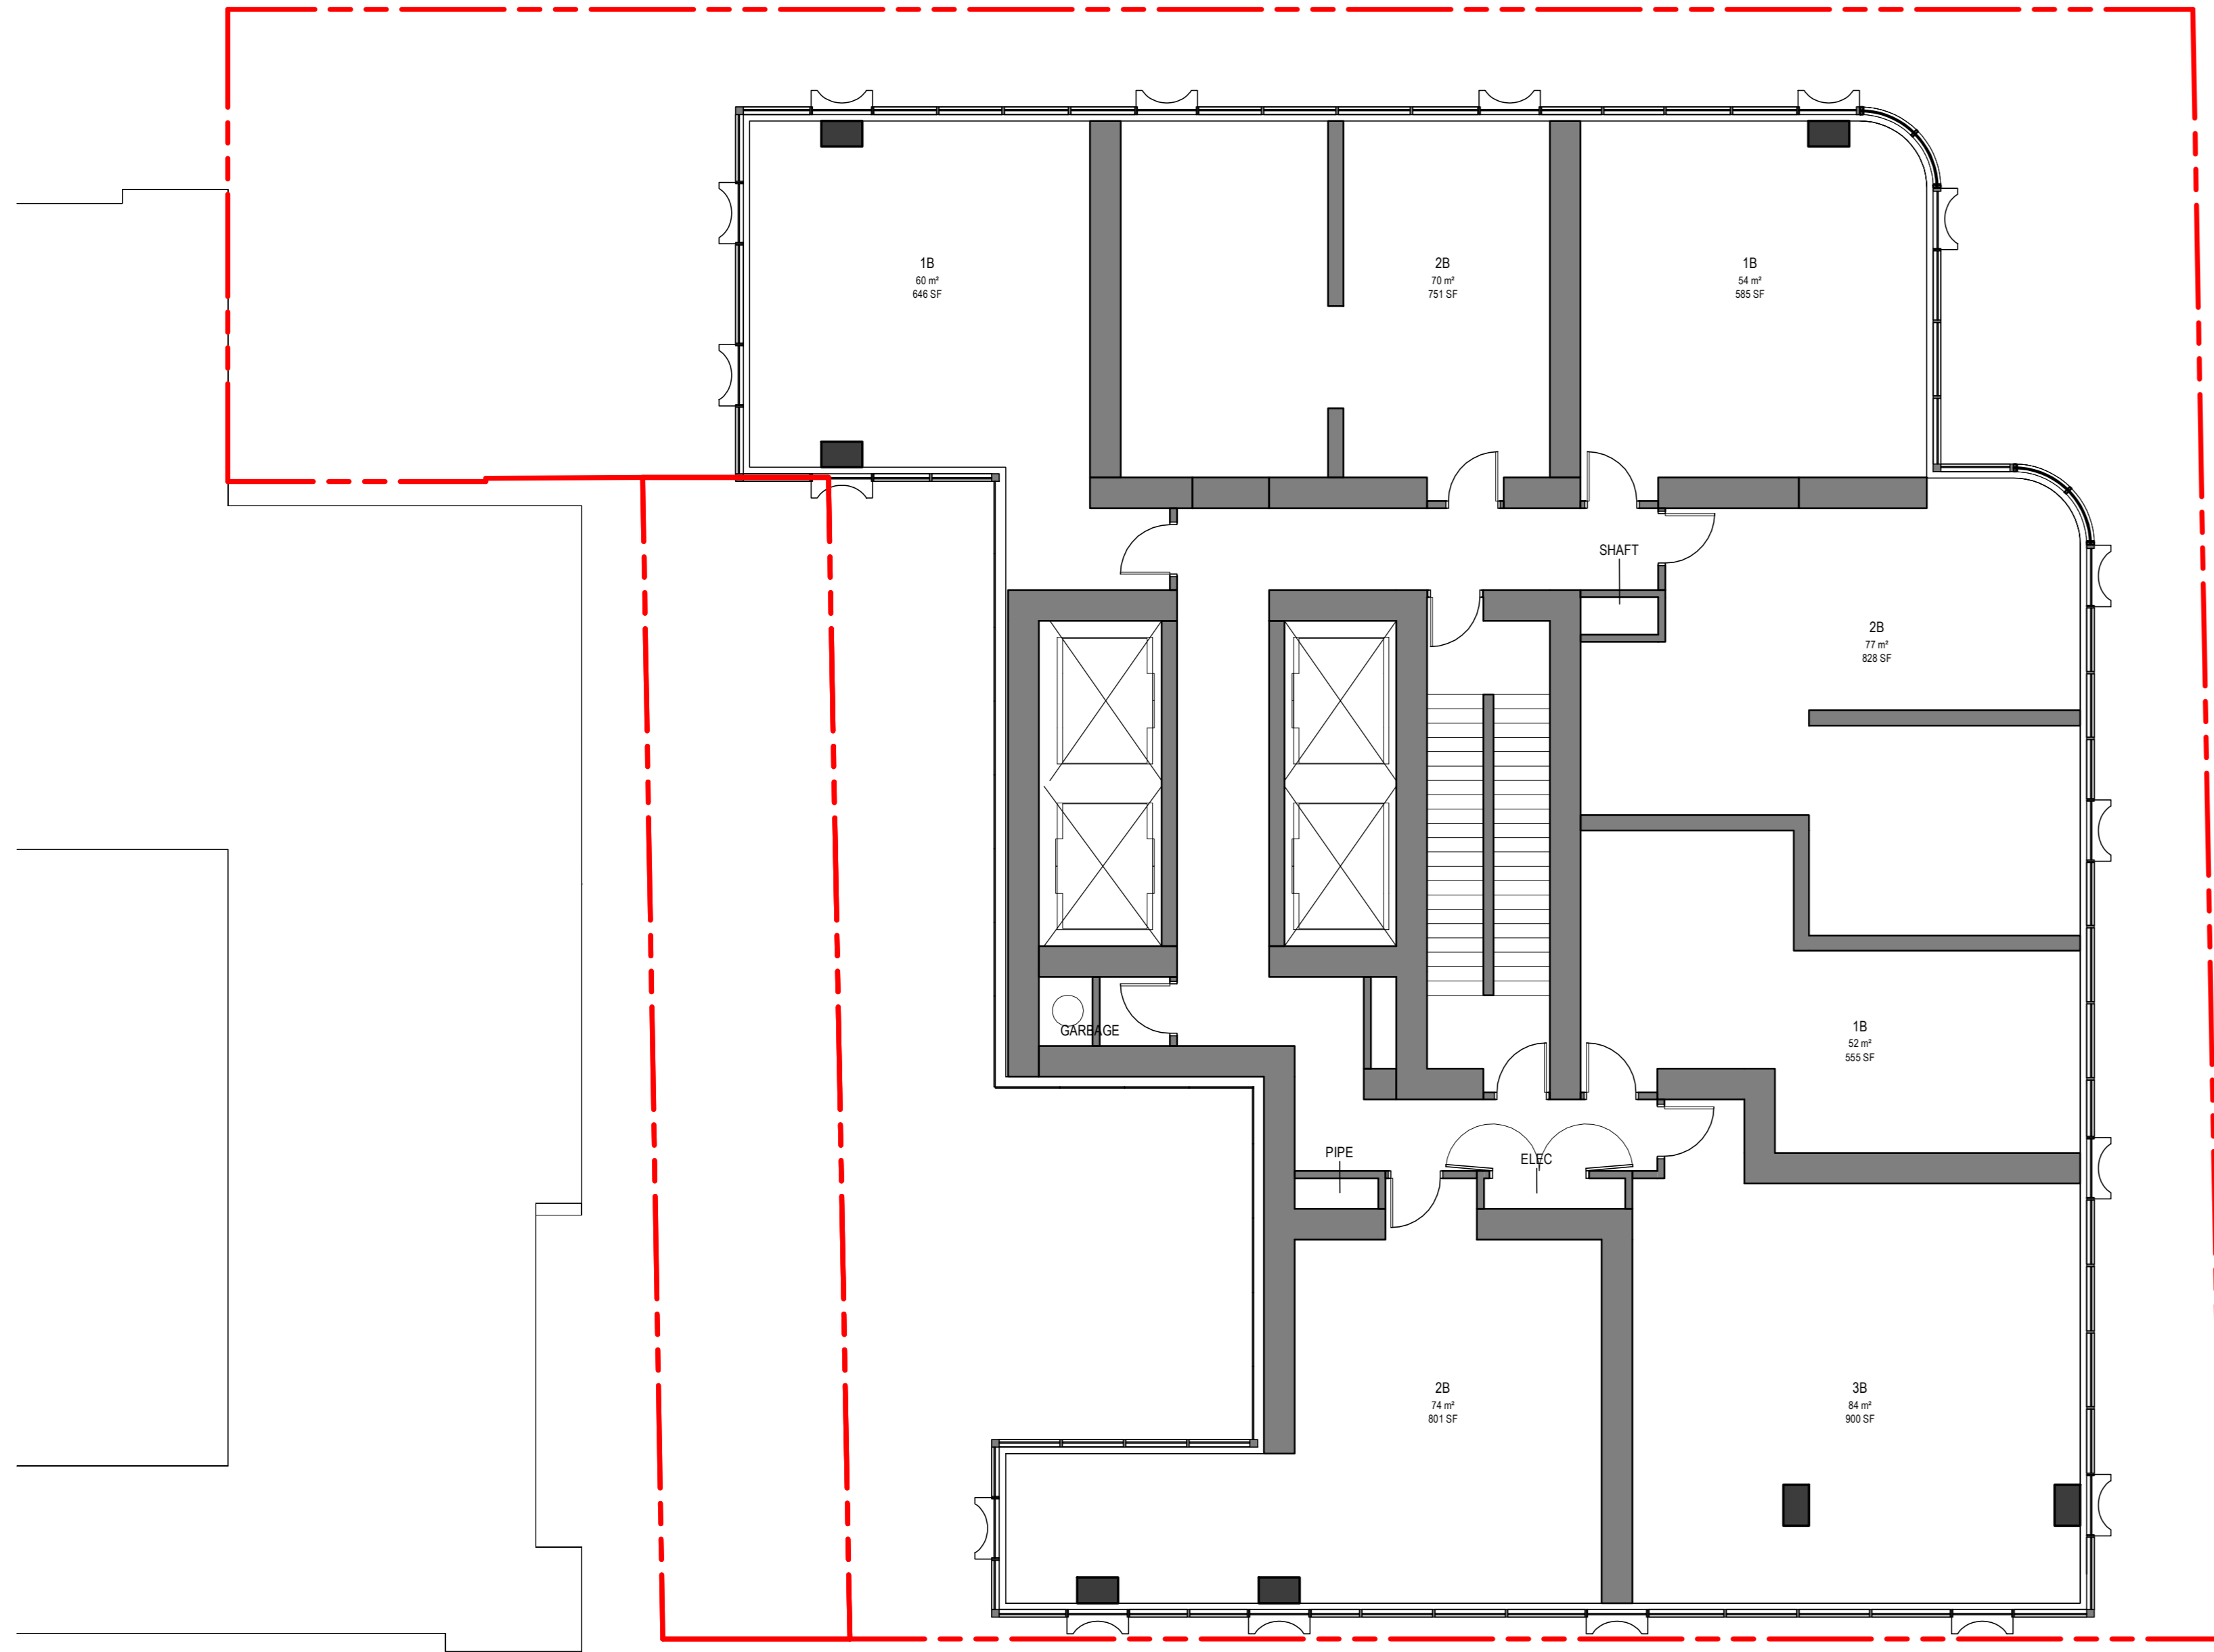


4 TYP TOWER PH
DP2.3 SCALE: 1:100

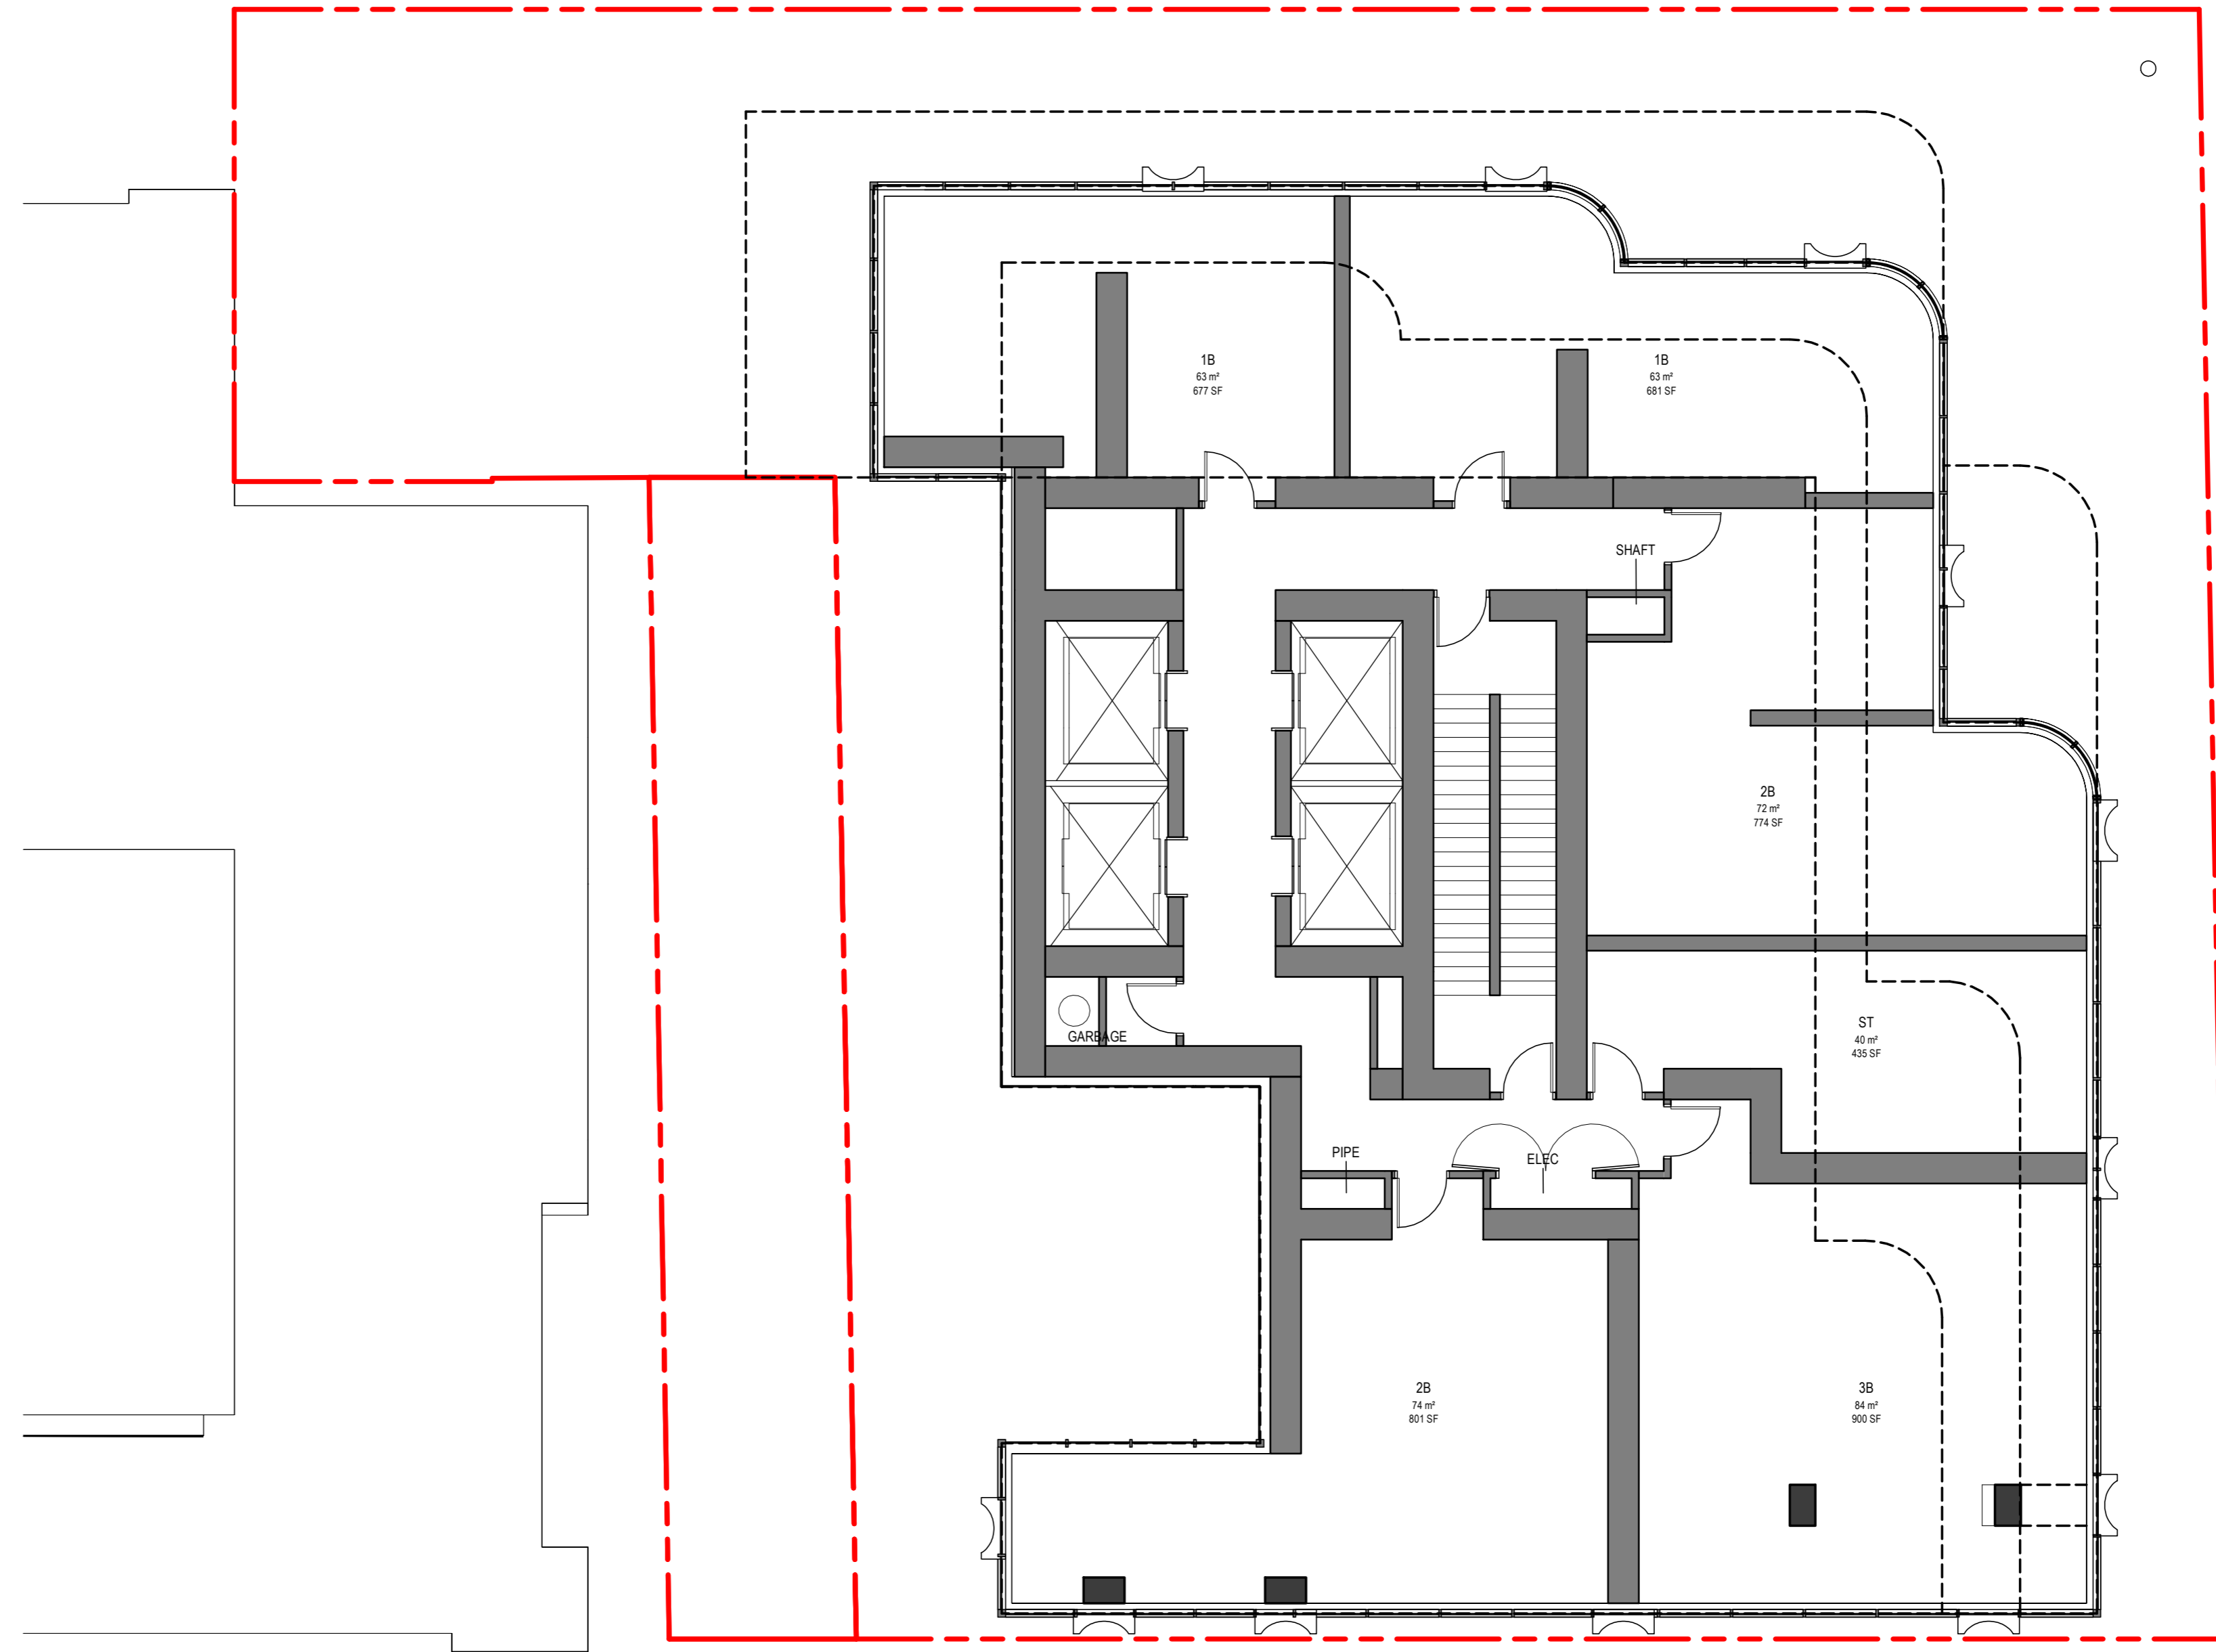

3 L7-8
DP2.3 SCALE: 1:100

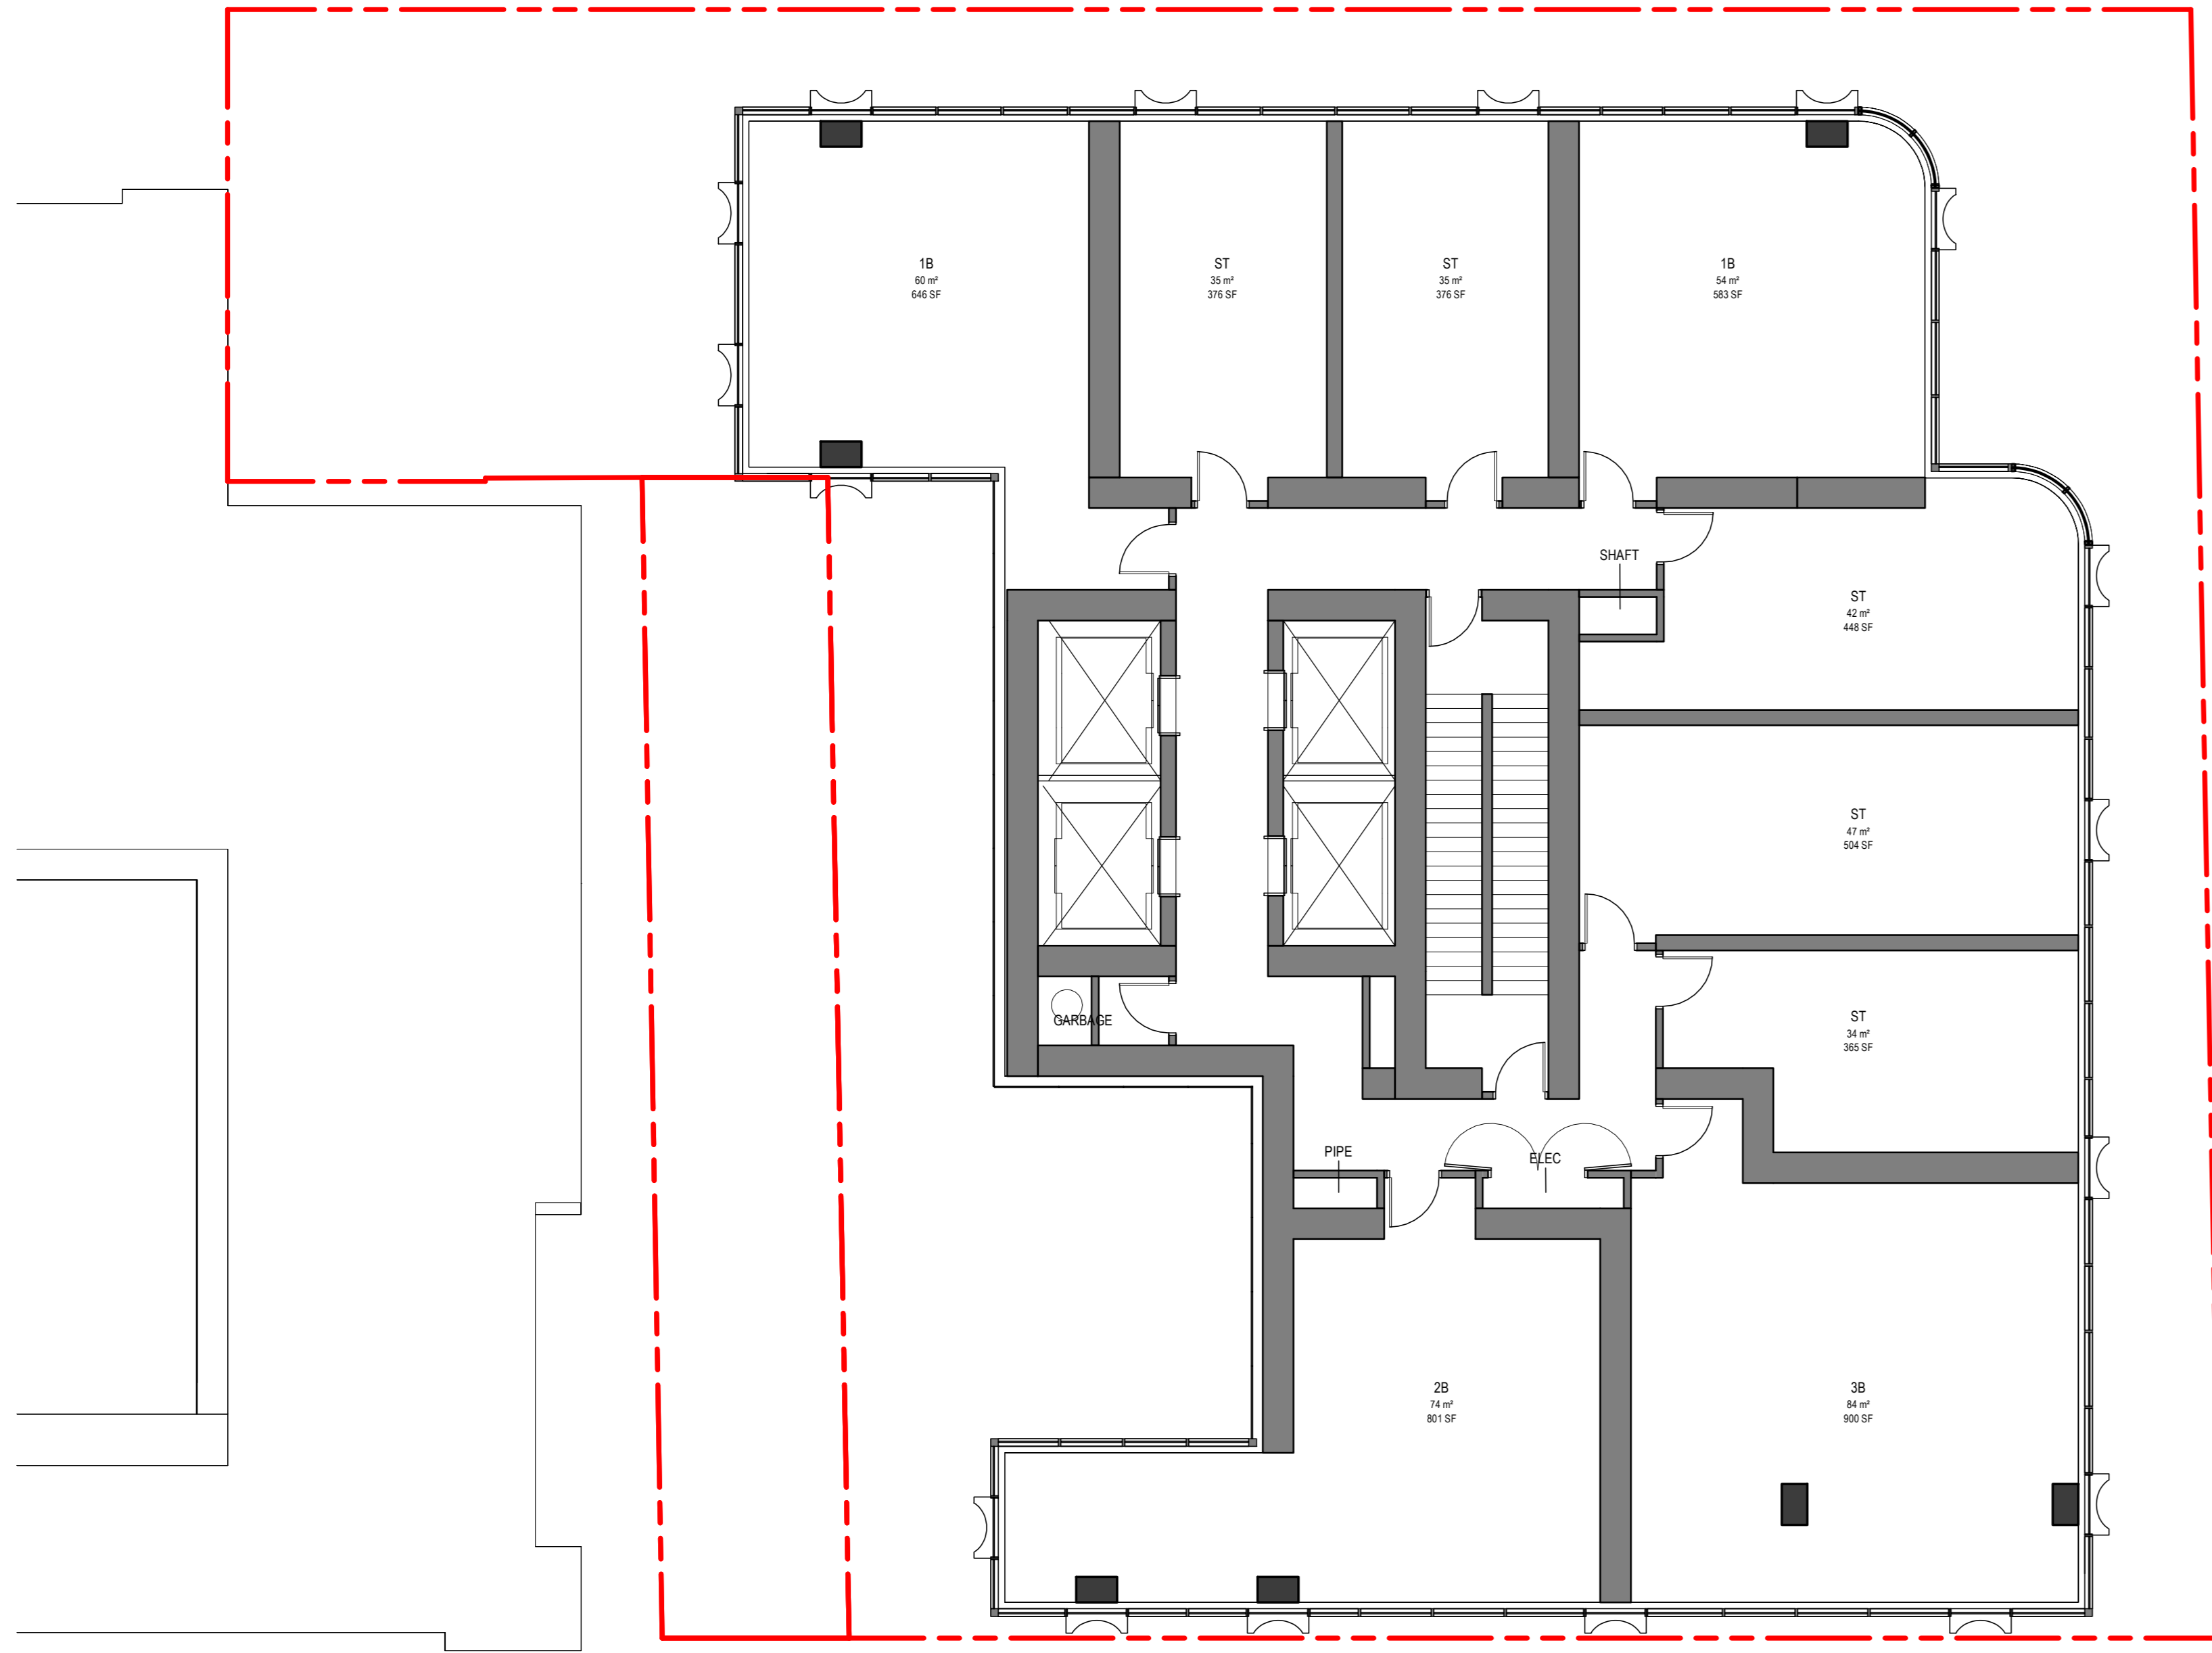

1 TYP TOWER
DP2.3 SCALE: 1:100

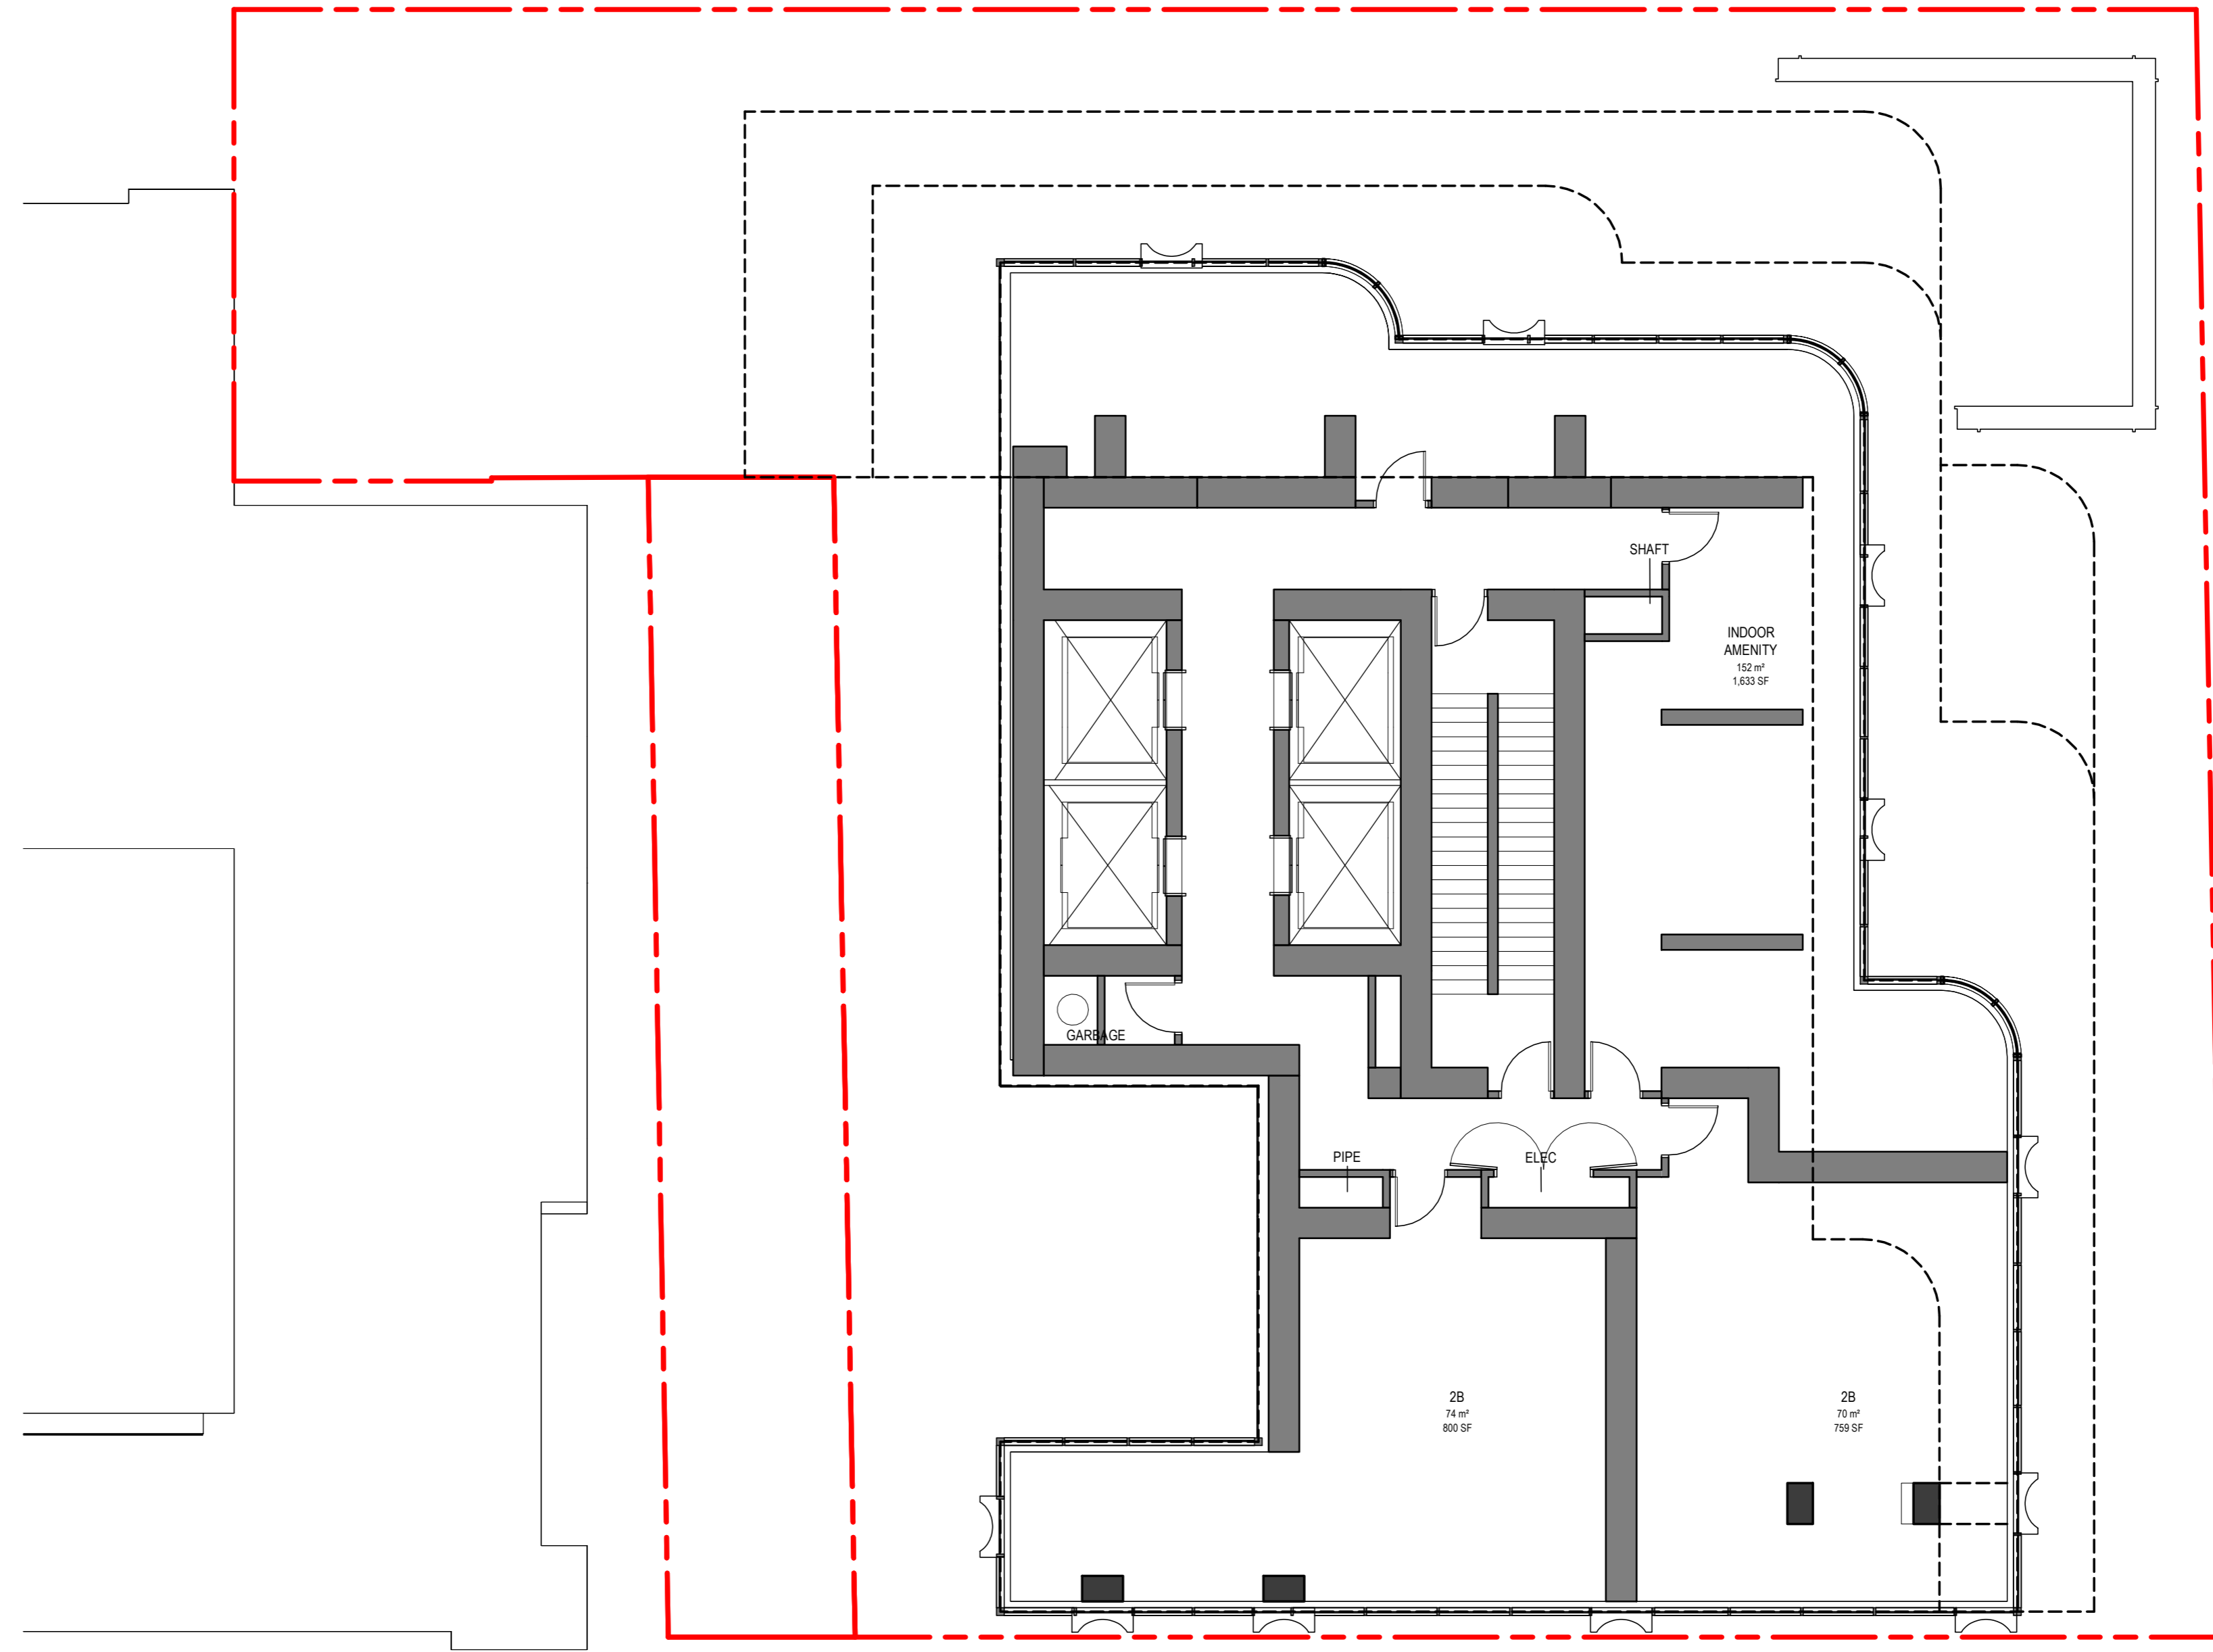

2 L5-6
DP2.3 SCALE: 1:100

ISSUED FOR

- 1 2020-06-11 ISSUED FOR ZBA
- 2 2021-09-08 REISSUED FOR ZBA
- 3 2021-09-08 ISSUED FOR SPA
- 4 2022-10-12 REISSUED FOR ZBA
- 5 2023-01-23 REISSUED FOR ZBA
- 6 2023-10-26 REISSUED FOR ZBA

METRIC

THIS DRAWING IS COPYRIGHTED AND MUST NOT BE USED, REPRODUCED, OR REVISED WITHOUT WRITTEN PERMISSION. ALL DIMENSIONS ARE IN MILLIMETERS UNLESS OTHERWISE NOTED. VERIFY DIMENSIONS. DO NOT SCALE THIS DRAWING. REPORT INCONSISTENCIES AND OMISSIONS TO THE CONSULTANT FOR CLARIFICATION BEFORE COMMENCING WITH THE WORK. DEVIATIONS FROM THE CONTRACT DOCUMENTS WITHOUT WRITTEN APPROVAL FROM THE CONSULTANT ARE SUBJECT TO CORRECTION AT THE CONTRACTOR'S EXPENSE.

ARCHITECT & PRIME CONSULTANT

DIALOG
35 John St #200
Toronto, ON M5V 3G6
Tel: (416) 966-0220 Fax:
CIVIL ENGINEER
Courtesport Engineering Inc.
8395 Jane St, Suite 100
Vaughan, ON L4K 3Y2 Fax:
Tel: (905) 526-1604
LANDSCAPE ARCHITECT
Fenn & Associates Inc
11 Church St
Toronto, ON M5E 1W1 Fax:
Tel: (416) 366-6800
STRUCTURAL ENGINEER
Jadlovsky, Ad and Partners International
400-3 Concorde Gate
Toronto, ON M5C 3N7 Fax:
Tel: (416) 447-7405
MECHANICAL ENGINEER
Smith + Anderson
100 Sheppard Ave E
North York, ON M2N 6N5 Fax:
Tel: (416) 487-8151
ELECTRICAL ENGINEER

Tel: Fax:

KEYPLAN

SEAL

YONGE & GERRARD

FLOOR PLANS

DRAWN: Author CHECKED: Checker
PLOT DATE: 2023-10-24 13:47:22

DP2.3

ISSUED FOR

- 1 2020-06-11 ISSUED FOR ZBA
- 2 2021-09-08 REISSUED FOR ZBA
- 3 2021-09-08 ISSUED FOR SPA
- 4 2023-01-23 REISSUED FOR ZBA
- 5 2023-10-26 REISSUED FOR ZBA

METRIC


THIS DRAWING IS COPYRIGHTED AND MUST NOT BE USED, REPRODUCED, OR REVISED WITHOUT WRITTEN PERMISSION. ALL DIMENSIONS ARE IN MILLIMETERS UNLESS OTHERWISE NOTED. VERIFY DIMENSIONS. DO NOT SCALE THIS DRAWING. REPORT INCONSISTENCIES AND OMISSIONS TO THE CONSULTANT FOR CLARIFICATION BEFORE COMMENCING WITH THE WORK. DEVIATIONS FROM THE CONTRACT DOCUMENTS WITHOUT WRITTEN APPROVAL FROM THE CONSULTANT ARE SUBJECT TO CORRECTION AT THE CONTRACTOR'S EXPENSE.

ARCHITECT & PRIME CONSULTANT

DIALOG
35 John St #200
Toronto, ON M5V 3G6
Tel: (416) 966-0220 Fax:
CIVIL ENGINEER
Courtyard Engineering Inc.
8395 Jane St, Suite 100
Vaughan, ON L4K 5T2
Tel: (905) 526-1644 Fax:
LANDSCAPE ARCHITECT
Fenn & Associates Inc
11 Church St
Toronto, ON M5E 1W1
Tel: (416) 366-6800 Fax:
STRUCTURAL ENGINEER
Jadlovsky, Ash and Partners International
400-3 Concorde Gate
Toronto, ON M6C 3N7
Tel: (416) 447-7405 Fax:
MECHANICAL ENGINEER
Smith + Anderson
100 Sheppard Ave E
North York, ON M2N 6N5
Tel: (416) 487-8151 Fax:
ELECTRICAL ENGINEER

Tel: Fax:
KEYPLAN

SEAL

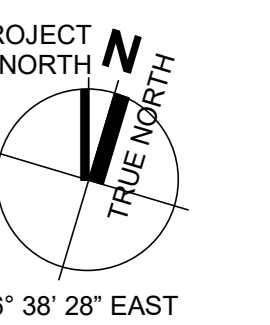


YONGE & GERRARD


FLOOR PLANS

DRAWN: Author CHECKED: Checker
PLOT DATE: 2023-10-24 13:47:28


DP2.4

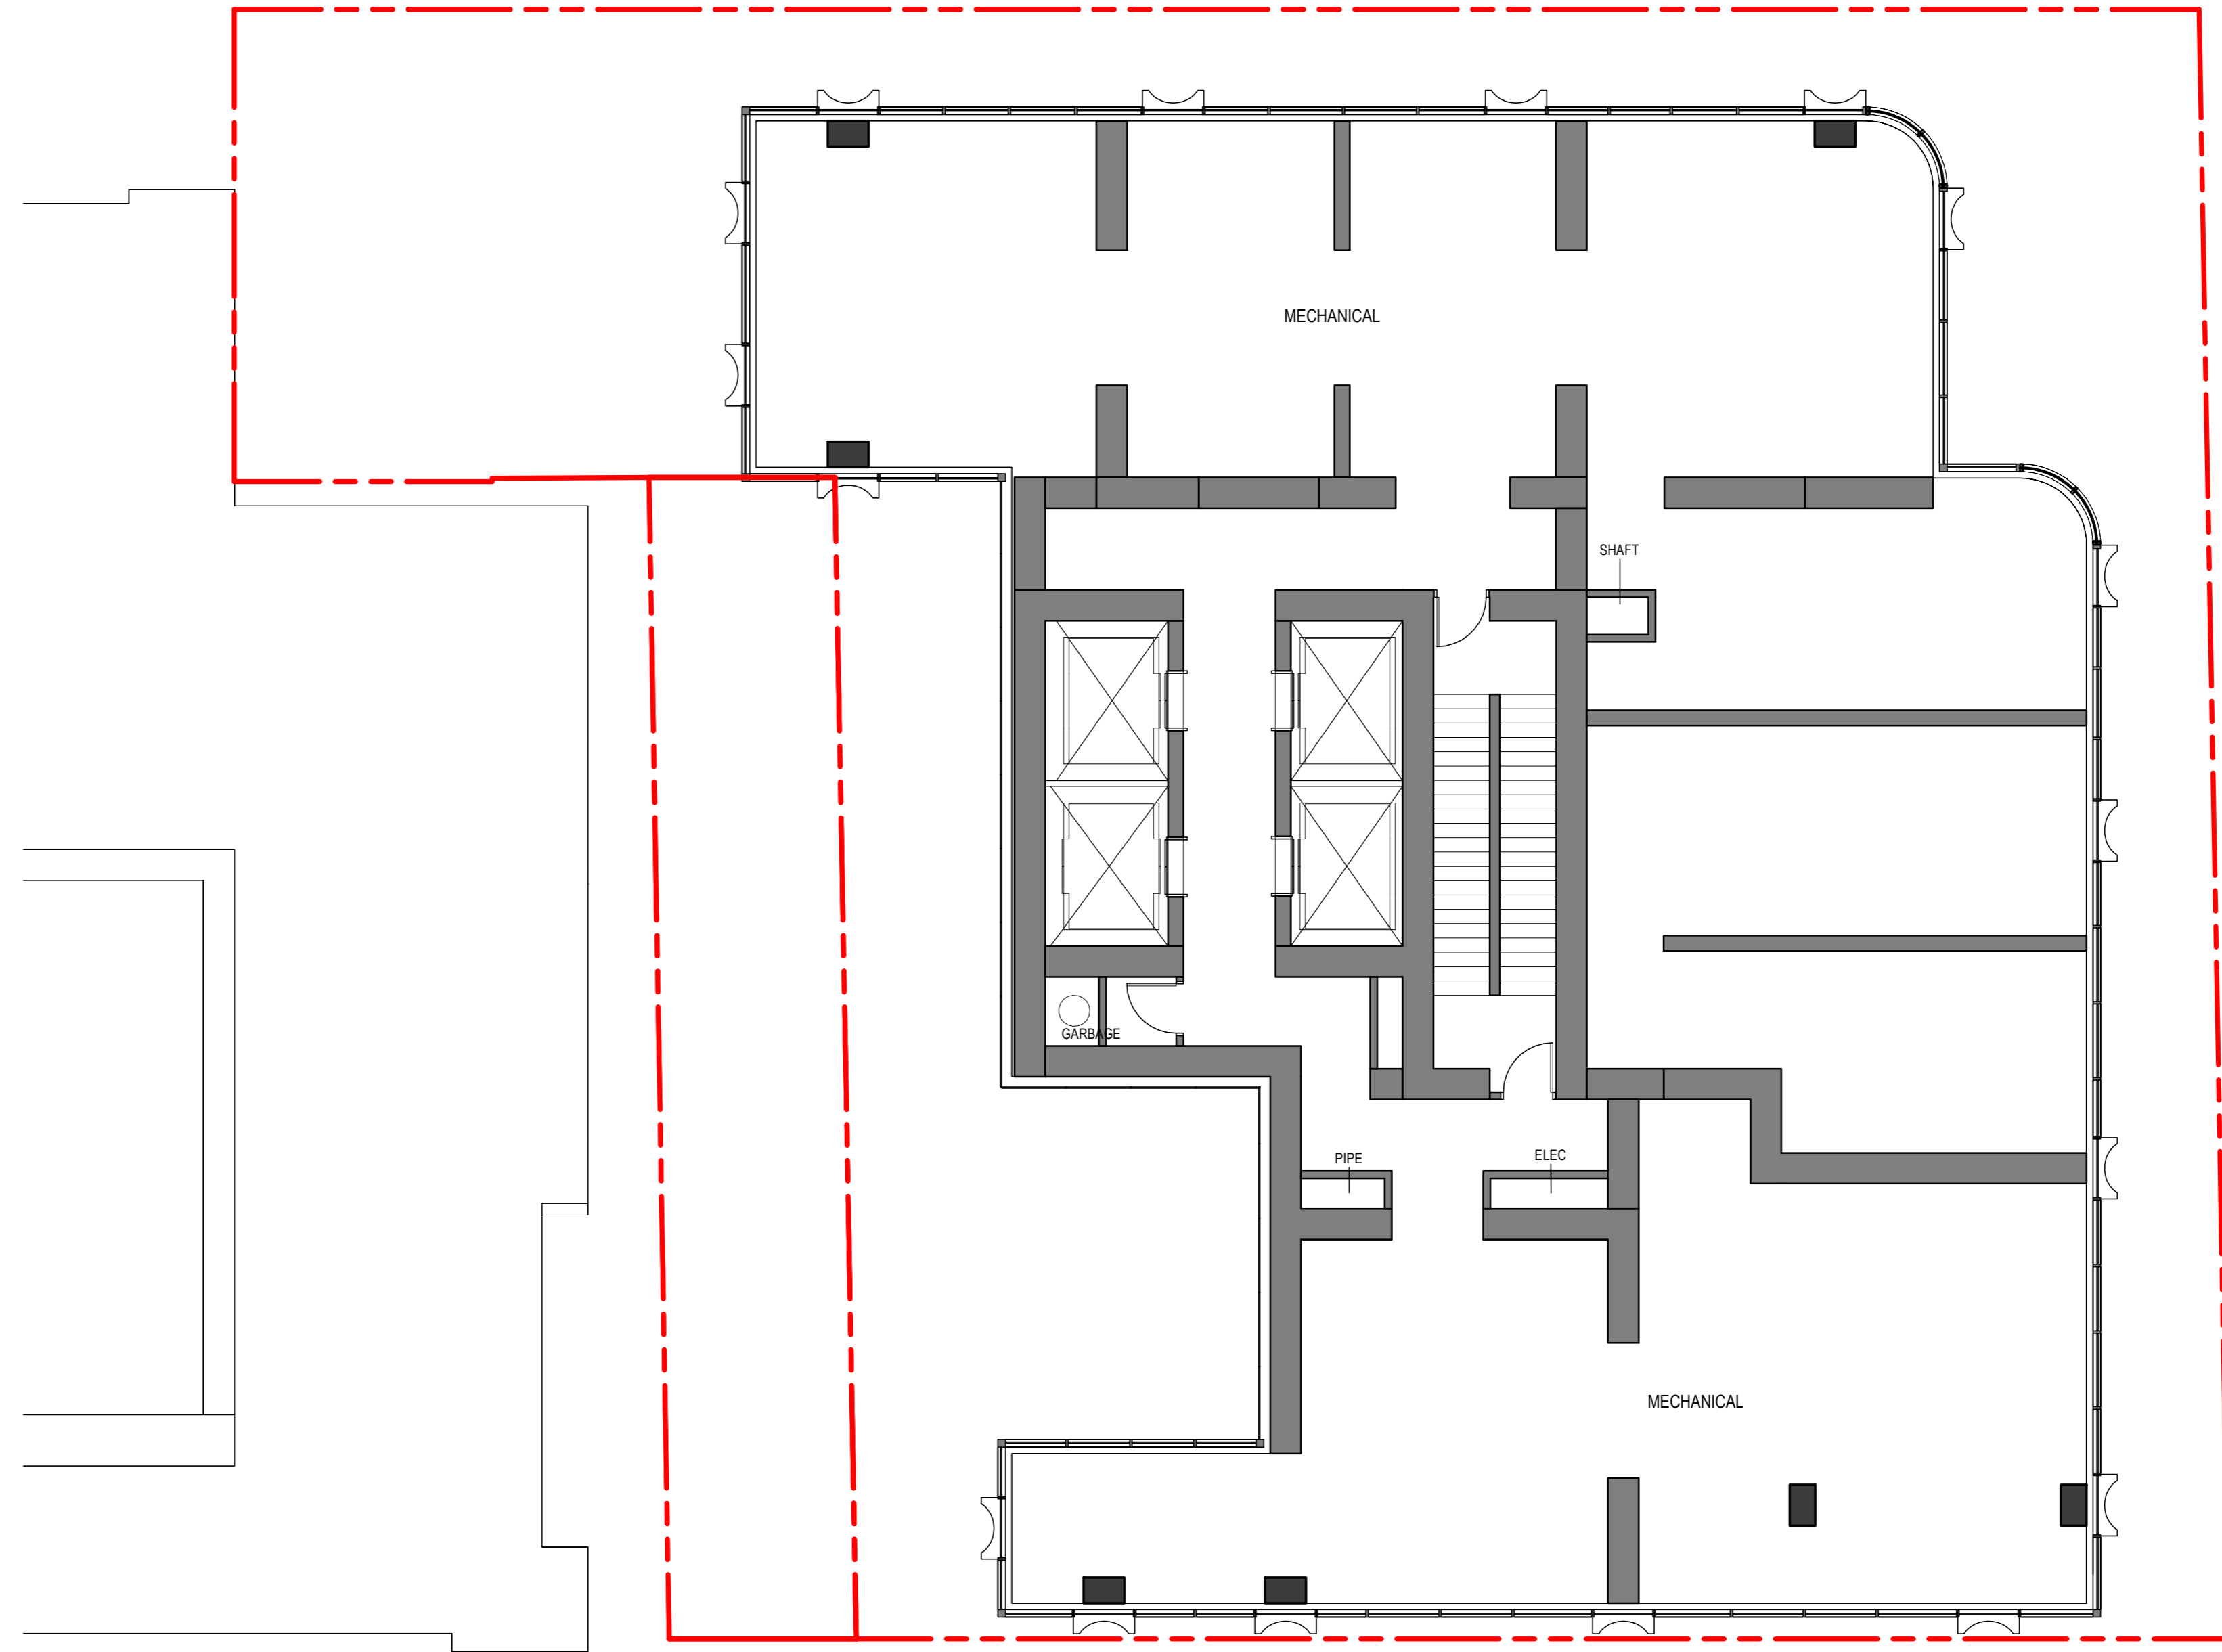

2 L33-34, L62-63 TYP MECH
DP2.4 SCALE: 1:100

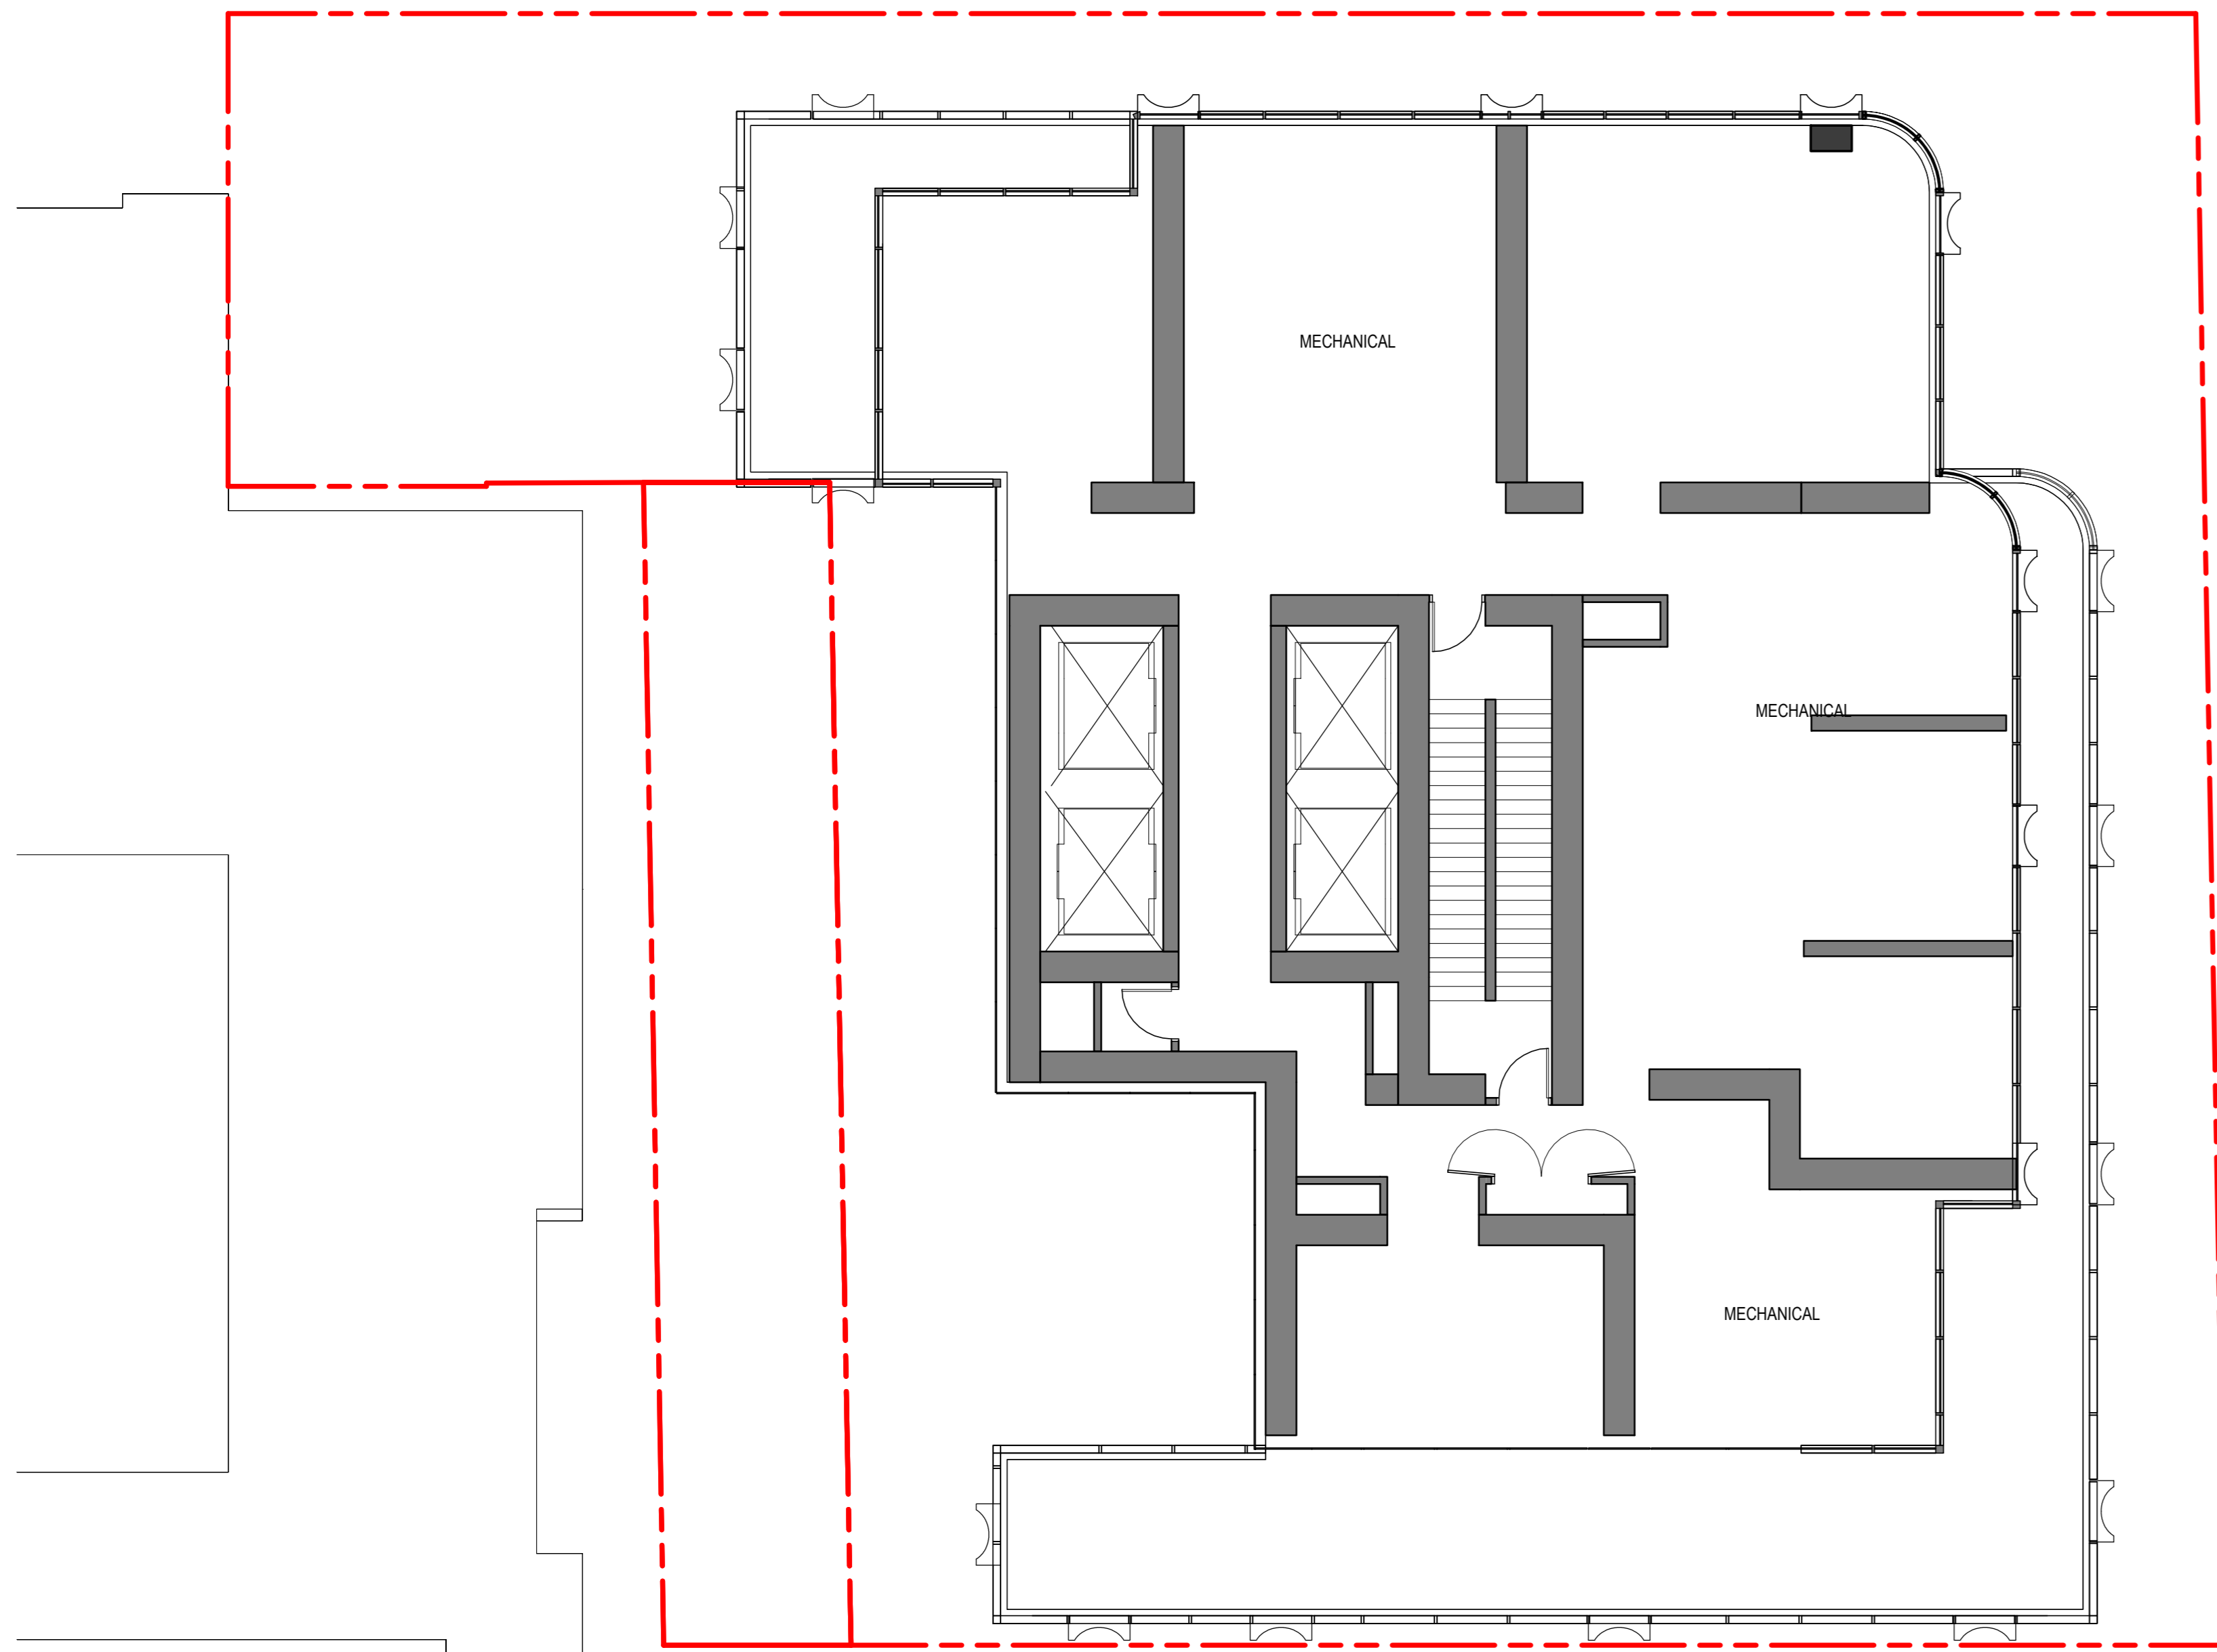

3 MECH PH
BP2.4 SCALE: 1:100

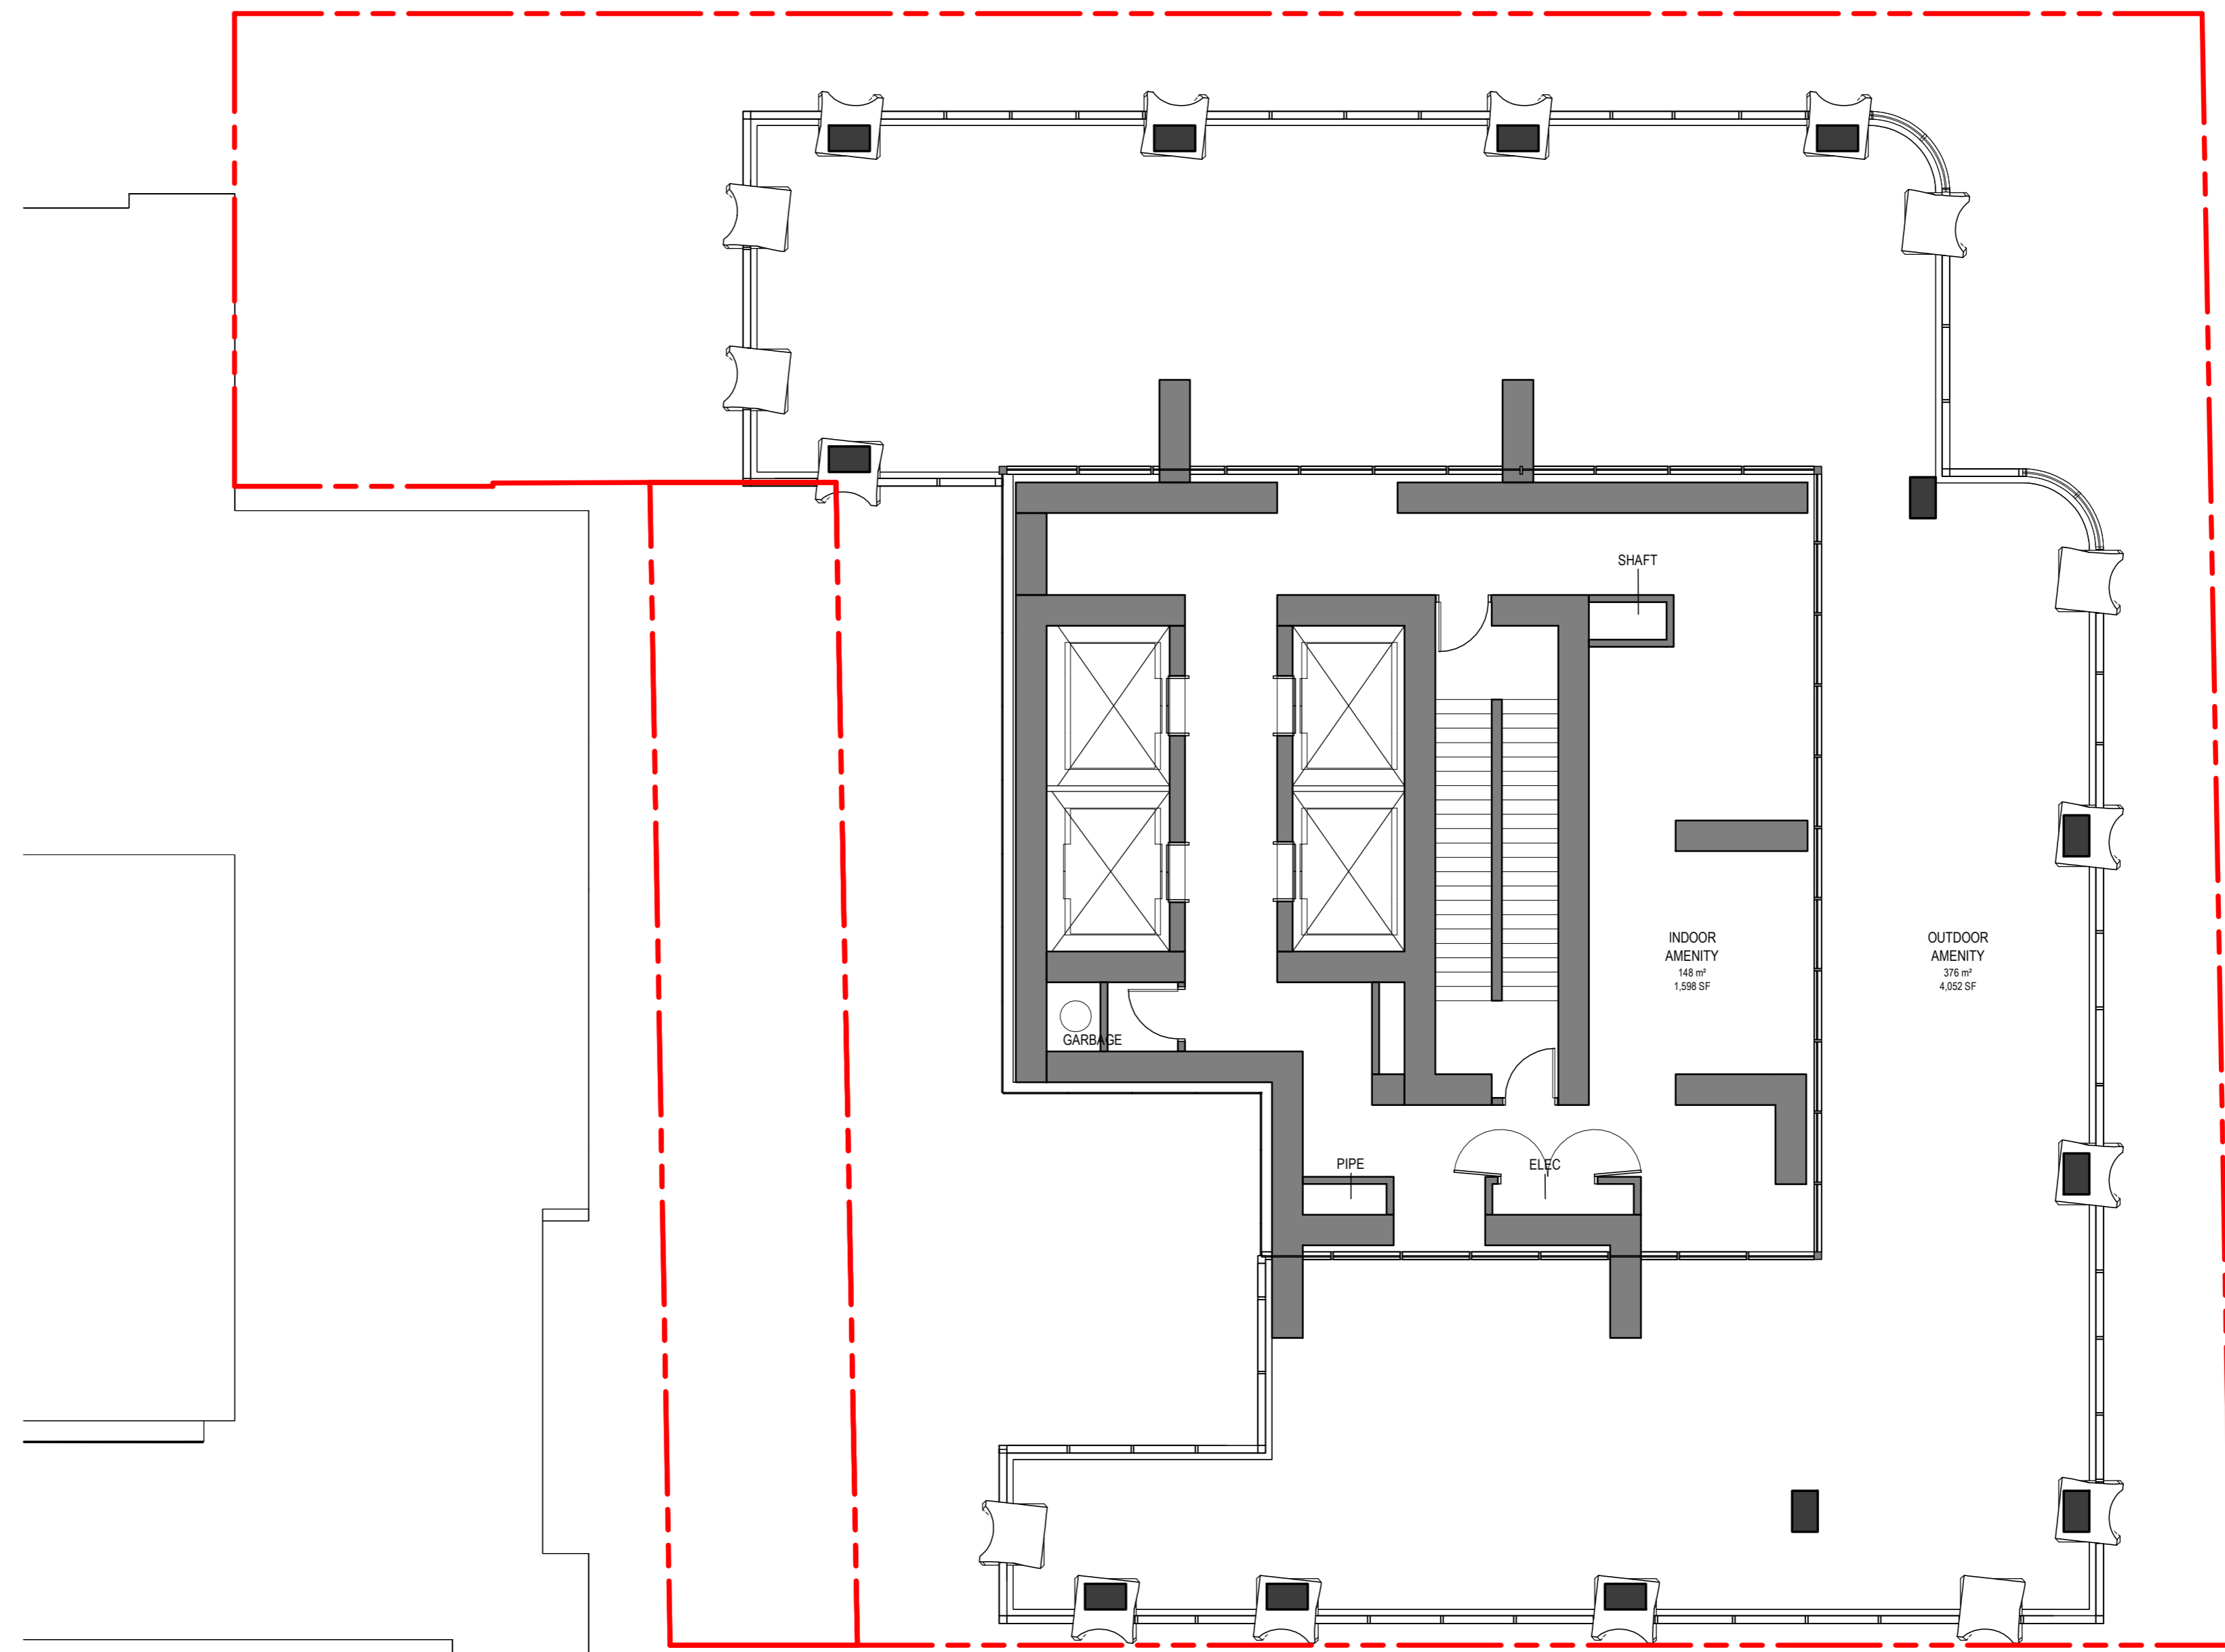

1 L31, L60 TYP AMENITY
DP2.4 SCALE: 1:100

