


Lighting Upgrades on Exhibition Place Grounds

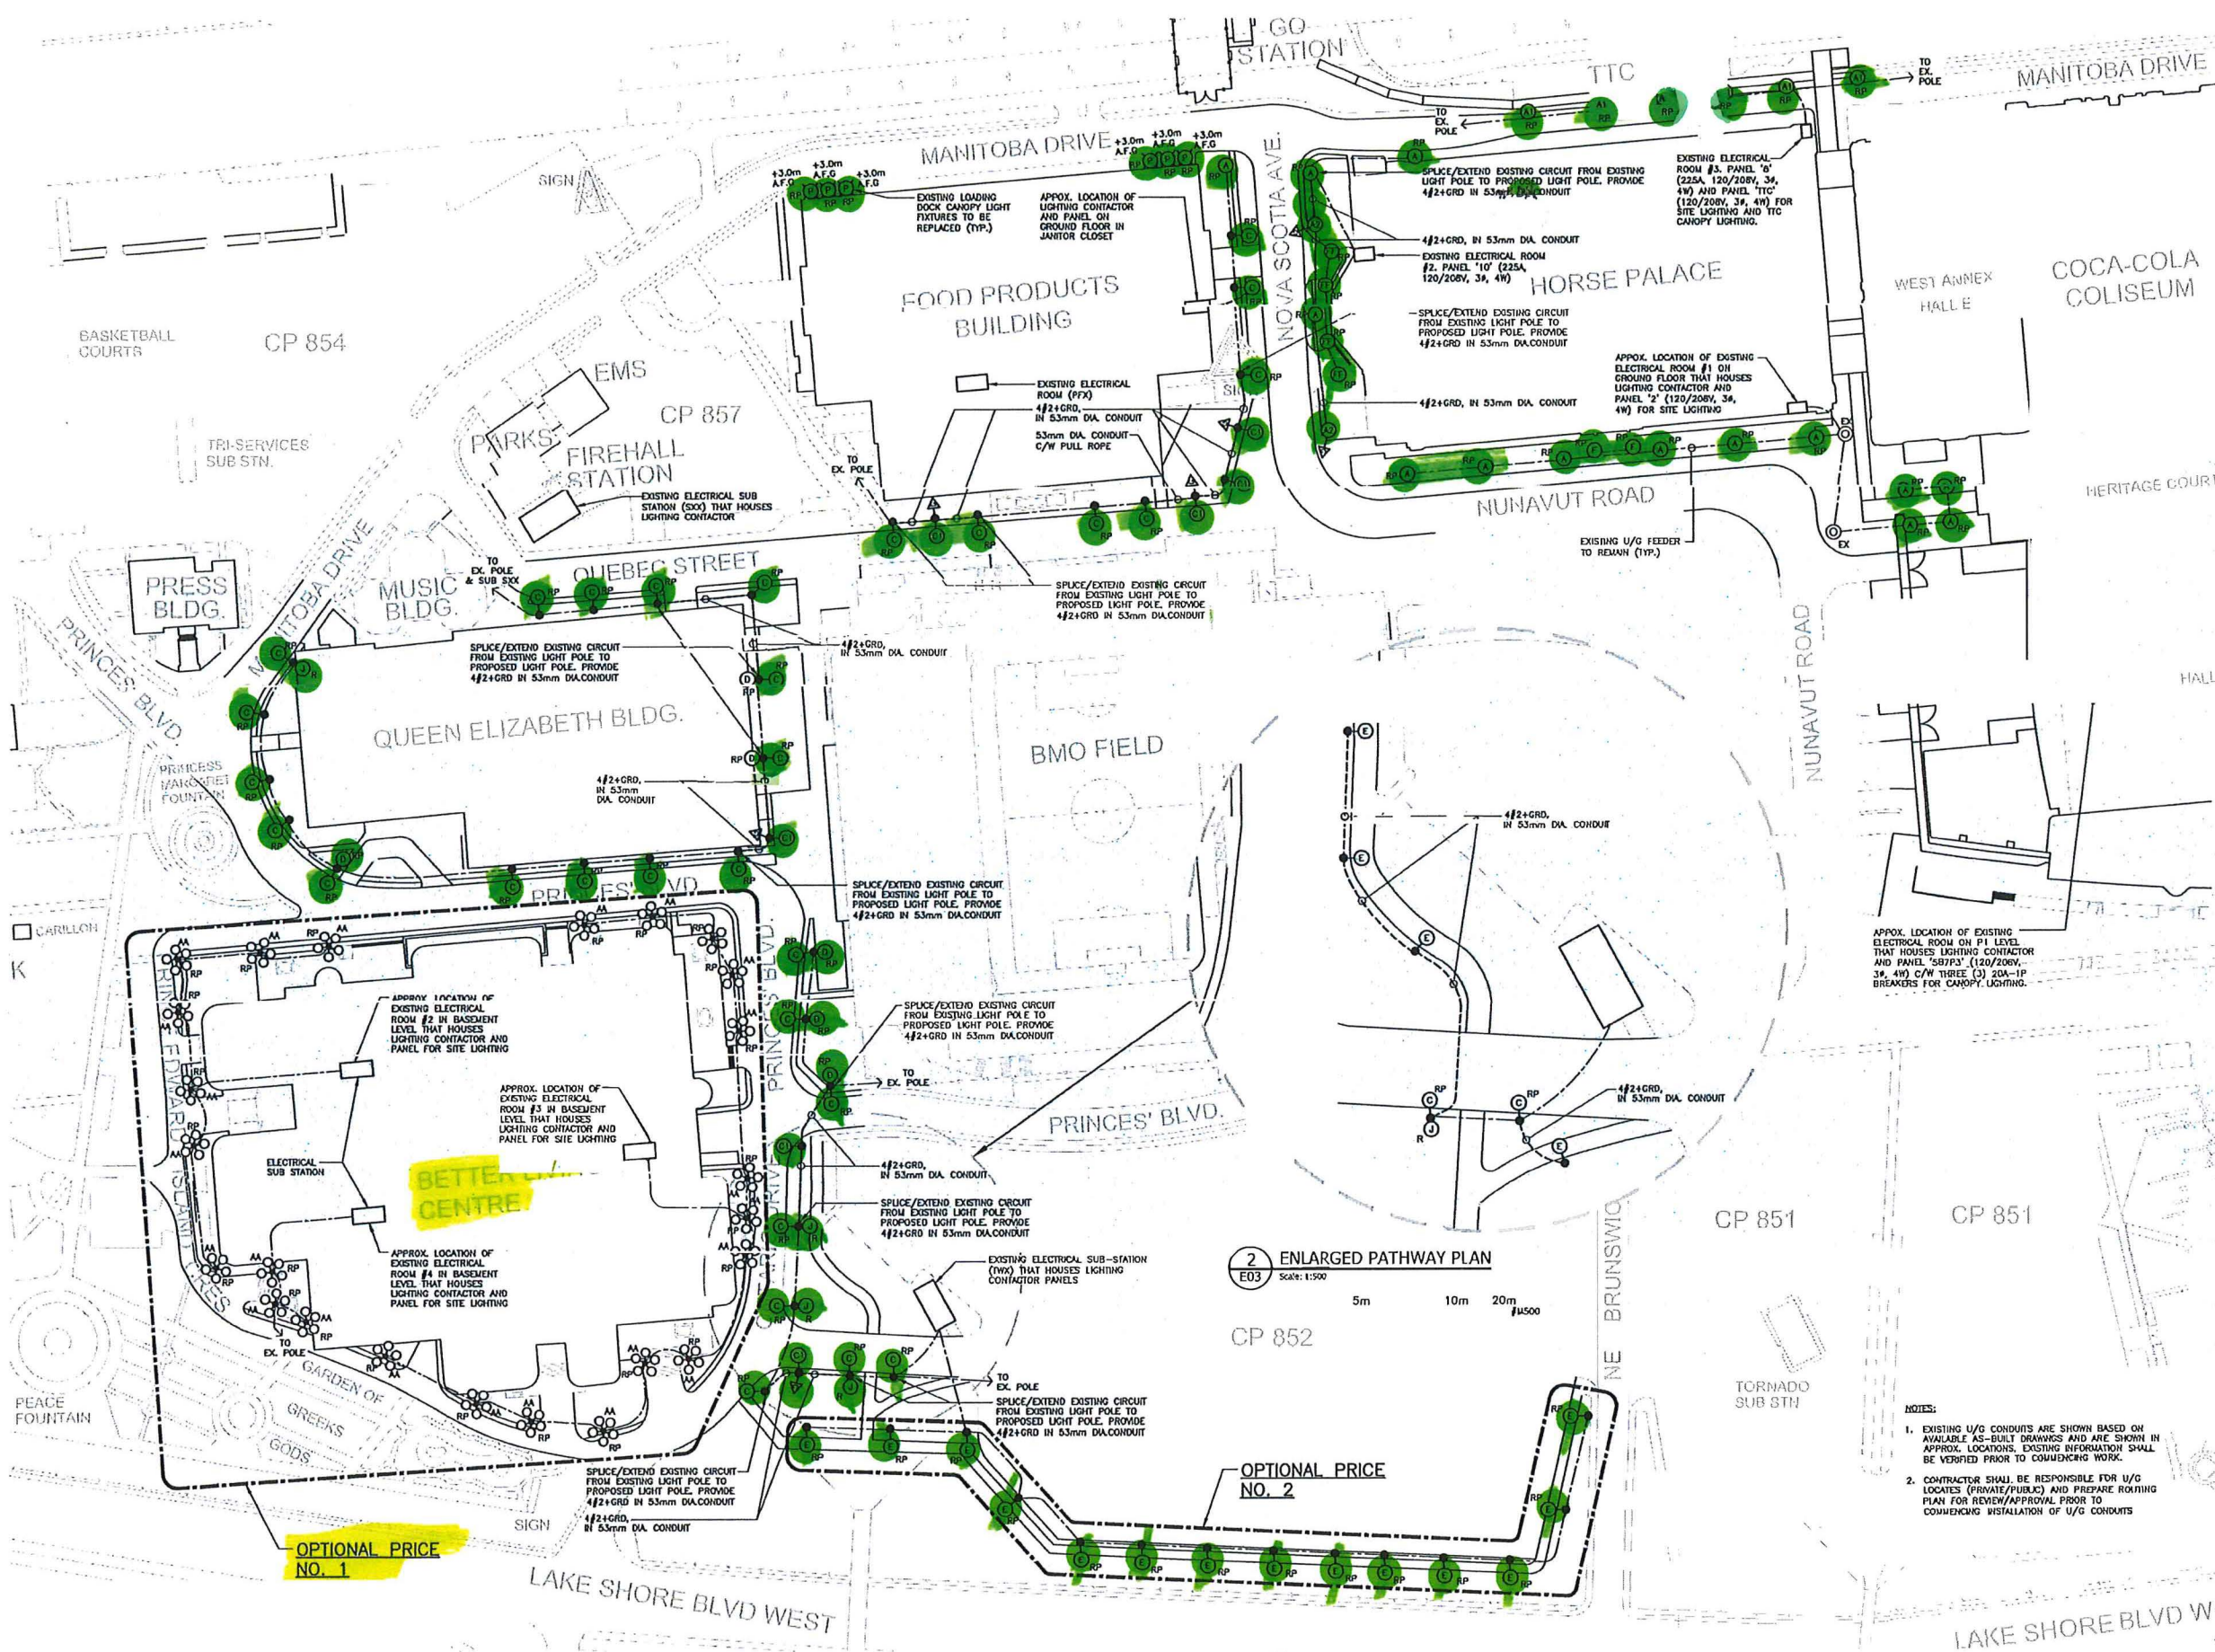

New light levels will be in accordance with Illuminating Engineering Society (RP-43-22) standard and City of Toronto's municipal code chapter 629

A - Existing Pole New Fixture

A1 - New Pole & New Fixture

C & D - Existing Pole New Dual Fixture

C1 - New Pole & New Fixture

E - Existing Pole New Fixture

P - Canopy Lights

3	24/03/25 VJA	ISSUED FOR 100% REVIEW
2	24/03/08 VJA	ISSUED FOR 90% REVIEW
1	23/12/04 VJA	ISSUED FOR 50% REVIEW
NO	DATE	BY
REVISIONS		

CHECK AND VERIFY ALL DIMENSIONS ON THE JOB BEFORE PROCEEDING WITH ANY WORK. DRAWING MUST NOT BE SCALED



STUDIO

Moon-Metz Ltd.
Consulting Engineers

PROJECT TITLE
SPORT AND RECREATION ZONE
LIGHTING UPGRADE

DRAWING TITLE
ENLARGED SITE LIGHTING PLAN

DESIGN BY	DATE	SCALE
V.M.	JUNE 2023	1:1000
DRAWN BY	PROJECT NO.	DRAWING NO.
N.V.		
CHECKED BY		
V.M.		

EXHIBIT N PL A E

- NOTES:
- EXISTING U/G CONDUITS ARE SHOWN BASED ON AVAILABLE AS-BUILT DRAWINGS AND ARE SHOWN IN APPROX. LOCATIONS. EXISTING INFORMATION SHALL BE VERIFIED PRIOR TO COMMENCING WORK.
 - CONTRACTOR SHALL BE RESPONSIBLE FOR U/G LOCATES (PRIVATE/PUBLIC) AND PREPARE ROUTING PLAN FOR REVIEW/APPROVAL PRIOR TO COMMENCING INSTALLATION OF U/G CONDUITS

2 ENLARGED PATHWAY PLAN
Scale: 1:500

1 ENLARGED SITE PLAN
Scale: 1:1000

10m 0 20m 40m